


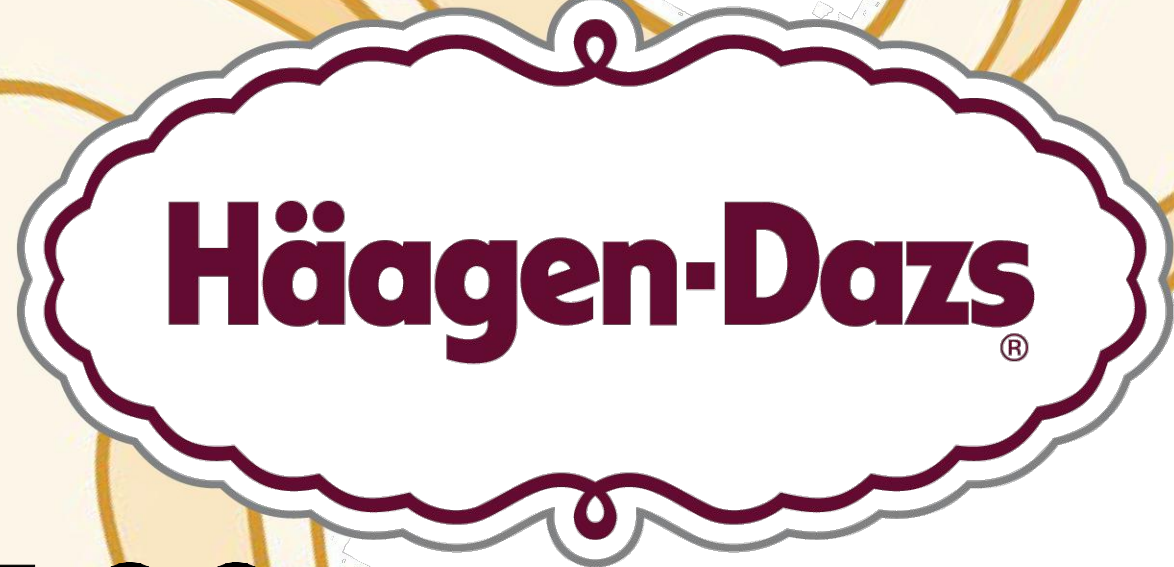

**40 S MAGNOLIA AVE.
STORE # 1436
OCALA, FL 34470**

PROJECT NUMBER: 250219

[illegible]

TIMOTHY M. LOTT
AIA, NCARB
 2225 E Randol Mill Rd, Suite 300
 Arlington, TX 76011
 (817) 701-4807

Project No.	250219
Scale	AS NOTED
Drawn	EL
Checked	CF
Date	10/09/25

COVER

Drawing No. **CS**

[illegible]

	EXIT TRAVEL PATH		EXIT LIGHT FIXTURE, REF: ELECTRICAL DRAWINGS.
	FIRE EXTINGUISHER		EMERGENCY LIGHT FIXTURE, REF: ELECTRICAL DRAWINGS.
	36" CLEAR PATH		

<u>TENANT OCCUPANCY:</u>	(B) BUSINESS, (M) MERCANTILE
<u>GROSS FLOOR AREA:</u>	1,300 SF
<u>OCCUPANCY LOAD:</u>	25

TOTAL NUMBER OF SEATS: 8 + 1 ACCESSIBLE SEAT
TOTAL NUMBER OF TABLES: 4
5% OF SEATING TO BE ACCESSIBLE: $0.05 \times 8 = 0.4$ (1)

EXITS PROVIDED: 1
MINIMUM WIDTH: 36" (<50 OCCUPANTS)

EXIT ACCESS TRAVEL DISTANCE
MAX TRAVEL = 200 FEET (NON SPRINKLERED)

MINIMUM PLUMBING FACILITIES - OCCUPANCY = B (BUSINESS

WATER CLOSET:
REQUIRED: FEMALE 1 PER 25 FOR FIRST 50; 1 PER 50
FOR REMAINDER
REQUIRED: MALE 1 PER 25 FOR FIRST 50; 1 PER 50
FOR REMAINDER
PROVIDED: (1) UNISEX

LAVATORIES:
REQUIRED: FEMALE 1 PER 40 FOR FIRST 80; 1 PER 80
FOR REMAINDER
REQUIRED: MALE 1 PER 40 FOR FIRST 80; 1 PER 80
FOR REMAINDER
PROVIDED: (1) UNISEX

DRINKING FOUNTAIN: NOT REQUIRED W/ WATER PROVIDED BY TENANT PER 410.4

SERVICE SINK:
REQUIRED: 1
PROVIDED: 1

DRINKING FOUNTAIN SUBSTITUTION: SECTION 410.4
WHERE RESTAURANTS PROVIDE DRINKING WATER IN A CONTAINER FREE OF
CHARGE, DRINKING SHALL NOT BE REQUIRED IN THOSE RESTAURANTS.

SEPARATE FACILITIES: SECTION 403.2 EXCEPTION 4
SEPARATE FACILITIES SHALL NOT BE REQUIRED IN BUSINESS OCCUPANCIES IN WHICH THE MAXIMUM OCCUPANT LOAD IS 25 OR FEWER.

PROVIDE EXIT SIGNS AND DIRECTIONAL EXIT SIGNS AT LOCATIONS STROKE ON THE FLOOR PLAN. EXIT SIGNS SHALL HAVE A MAXIMUM 6" HIGH BY 3/4" STROKE BLOCK LETTERS ON A CONTRASTING BACKGROUND.

EMERGENCY LIGHTING SHALL BE PROVIDED BY TWO ELECTRIC LAMPS OR SHALL BE OF APPROVED SELF-LUMINOUS TYPE. IF TWO LAMPS ARE USED, POWER SUPPLY TO ONE OF THE LAMPS SHALL BE PROVIDED BY THE PREMISES WIRING SYSTEM, POWER SUPPLY TO THE OTHER LAMP SHALL BE FROM STORAGE BATTERIES. THE SYSTEM SHALL BE INSTALLED IN ACCORDANCE WITH THE NATIONAL ELECTRIC CODE.


EMERGENCY LIGHTING SHALL BE PROVIDED FROM AN EMERGENCY POWER SYSTEM AND SHALL PROVIDE A VALUE OF ONE FOOT CANDLE AT FLOOR LEVEL.

FIRE MARSHAL TO DETERMINE FINAL QUANTITIES AND LOCATION OF FIRE EXTINGUISHERS.

- DOOR ENTRY THRESHOLD WILL NOT EXCEED 1/2" MAX.
- ALL FLOORING SHALL BE LEVEL AND SLIP RESISTANCE THROUGHOUT.

PROVIDE FIRE EXTINGUISHER: 2A-10BC - DRY-CHEM TYPE (WALL MOUNT BRACKET, SEE THIS SHEET FOR SUGGESTED LOCATION. MINIMUM PROVIDED TO BE SLBS TYPE ABC).

- ALL INTERIOR FINISHES SHALL COMPLY WITH NFPA 101, 8TH EDITION, 10.2.2.
- DOORS SHALL NOT REQUIRE A KEY OR SPECIAL COMBINATION TO OPEN FOR EGRESS.

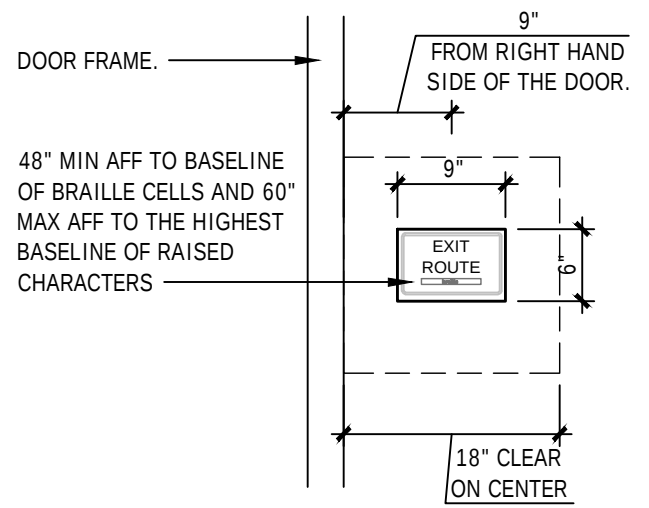
$$1/4'' = 1' - 0$$

$$1/4'' = 1' - 0$$

1/4"=1'-0"


[F] TABLE 906.3(1) FIRE EXTINGUISHERS FOR CLASS A FIRE HAZARDS.
MINIMUM RATED SINGLE FIRE EXTINGUISHER - SEE TABLE
MAXIMUM FLOOR AREAS - SEE TABLE
MAXIMUM DISTANCE OF TRAVEL TO EXTINGUISHER = 75'-0"

[F] 906.9 EXTINGUISHER INSTALLATION.
THE INSTALLATION OF PORTABLE FIRE EXTINGUISHERS SHALL BE IN
ACCORDANCE WITH SECTIONS 906.9.1 THROUGH 906.9.3.



[F] 906.9.1 EXTINGUISHERS WEIGHING 40 POUNDS OR LESS.
PORTABLE FIRE EXTINGUISHERS HAVING A GROSS WEIGHT NOT EXCEEDING 40 POUNDS (18 KG) SHALL BE INSTALLED SO THAT THEIR TOPS ARE NOT MORE THAN 5 FEET (1524 MM) ABOVE THE FLOOR.

[F] 906.9.2 EXTINGUISHERS WEIGHING MORE THAN 40 POUNDS.
HAND-HELD PORTABLE FIRE EXTINGUISHERS HAVING A GROSS WEIGHT
EXCEEDING 40 POUNDS (18 KG) SHALL BE INSTALLED SO THAT THEIR TOPS ARE
NOT MORE THAN 3.5 FEET (1067 MM) ABOVE THE FLOOR.

[F] 906.9.3 FLOOR CLEARANCE.
THE CLEARANCE BETWEEN THE FLOOR AND THE BOTTOM OF INSTALLED
HAND-HELD PORTABLE FIRE EXTINGUISHERS SHALL BE NOT LESS THAN 4 INCHES
(102 MM).

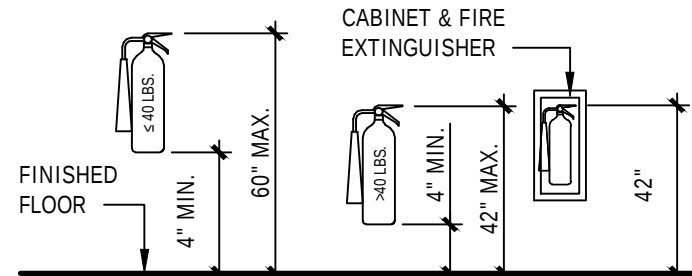

N.T.S.

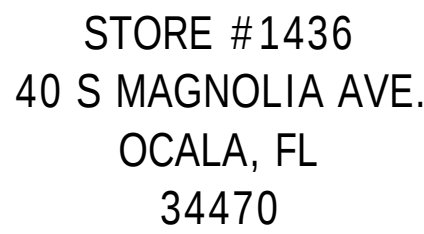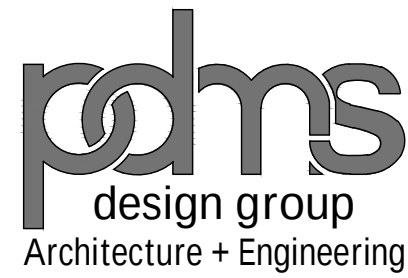[illegible]

2225 East Randol Mill Road, Suite #300
Arlington, Texas 76011
817.633.4200

This document contains information proprietary to PDMS Design Group and is furnished in confidence for the limited purpose of evaluation, bidding, review, or construction. This document or its contents may be used for any other purpose and may not be reproduced or disclosed to others without the prior written consent of PDMS Design Group.



TIMOTHY M. LOTT
AIA, NCARB
2225 E Randol Mill Rd, Suite 300
Arlington, TX 76011
(817) 701-4807

SEAL



Project No.	250219
-------------	--------

Scale	AS NOTED
-------	----------

Drawn	EL
-------	----

Checked	CF
---------	----


Date	10/09/25
------	----------

Drawing Title

OCCUPANCY & EGRESS PLAN

Drawing No.

A020

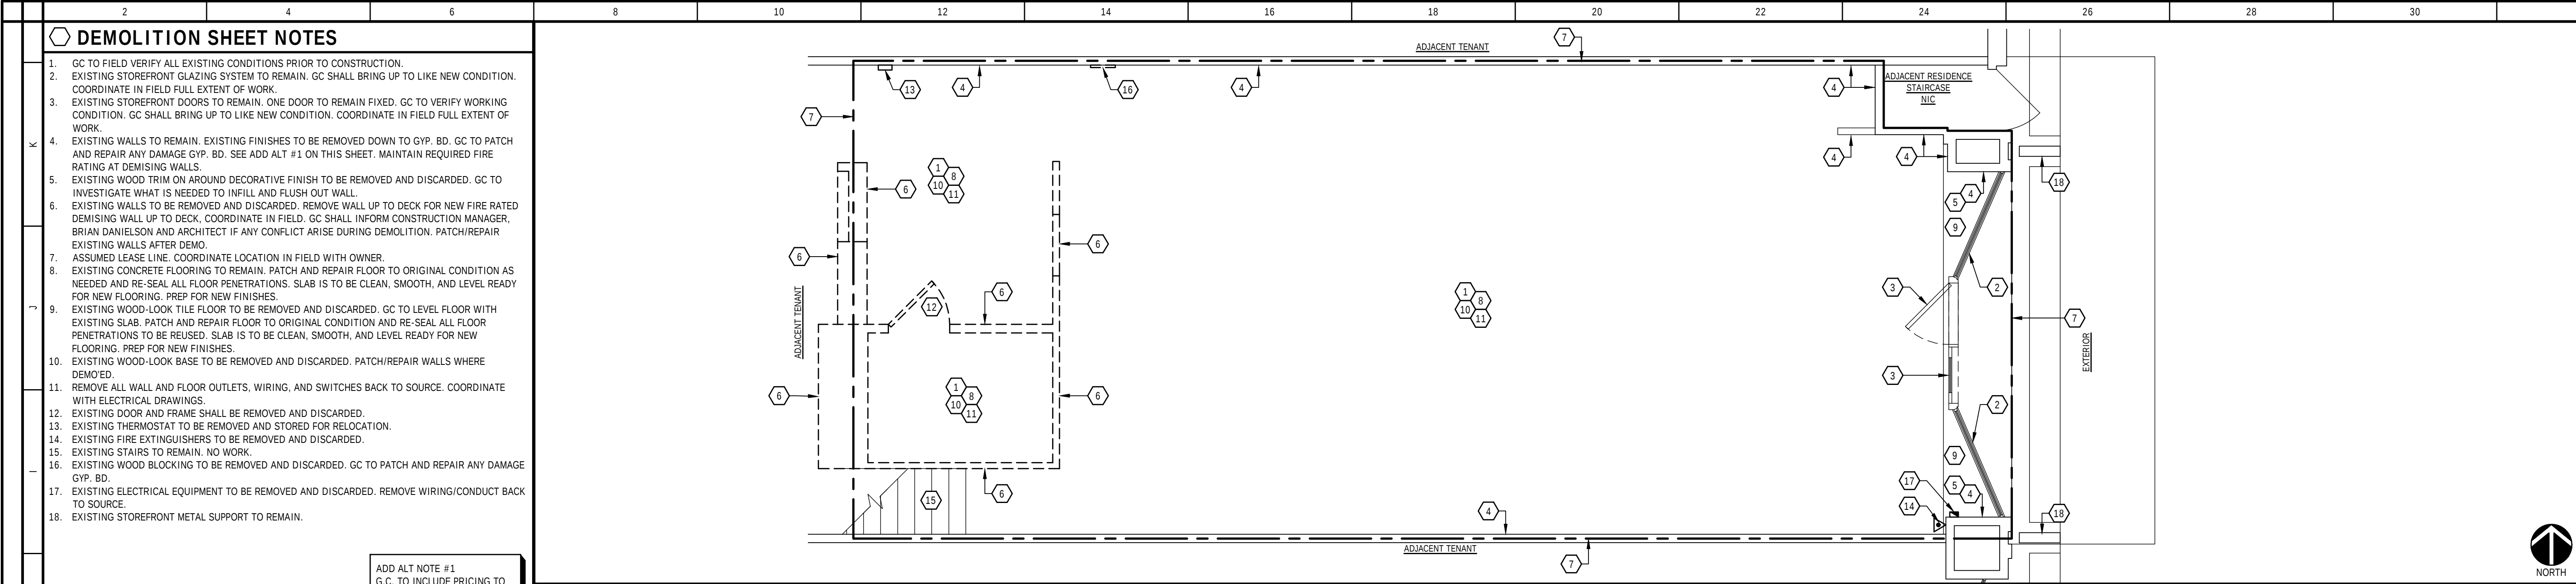

This figure contains architectural drawings for a food service equipment plan and schedule. It includes a title block with project information, a sheet notes section, a main equipment layout drawing, a detailed equipment schedule table, and a revision log.

SHEET NOTES

- LOW-TOP TABLE TOP TO BE 24" DIAMETER. TABLE TO BE FREE-STANDING. 34" A.F.F. MAX. IN WHITE LAMINATE; REFER A110 EQUIPMENT SCHEDULE A24A. BASE SHALL BE POWDER COATED TO MATCH BM-2.
- LOW-TOP TABLE TOP TO BE 40" DIAMETER. TABLE TO BE FREE-STANDING. 34" A.F.F. MAX. IN WHITE LAMINATE; REFER A110 EQUIPMENT SCHEDULE A24B. BASE SHALL BE POWDER COATED TO MATCH BM-2.
- CAFE CHAIRS REFER A400. FURNITURE FINISH SCHEDULE FM-3.
- TRANSILITE BOXES, TYP 9. REFER 11/A500 AND EQUIPMENT SCHEDULE E20.
- VINYL GRAPHIC . SIGN VENDOR TO SUPPLY AND INSTALL. REFER ELEVATIONS
- PRICING BOARD.
- POST MOUNTED ACRYLIC NEON LETTERING SIGNAGE, SUPPLIED AND INSTALLED BY SIGN VENDOR. REFER TO ELEVATIONS A310.
- OPENING IN SOLID SURFACE COUNTERTOP. FIXTURE VENDOR TO COORDINATE WITH EQUIPMENT SPECIFICATIONS, REFER TO 1/A420.
- TOPPINGS PAN IN TOPPINGS BOX. REFER TO 1/A430.
- BRAND WALL BACK-LIT CARTOUCHE APPLIED TO WALL. INSTALL CENTERED ON WALL. SIGN VENDOR TO SUPPLY AND INSTALL REFER TO ELEVATIONS A310.

FOOD SERVICE EQUIPMENT NOTES

- ALL FOOD SERVICE EQUIPMENT TO BE FURNISHED WITH CORD AND PLUG UNLESS OTHERWISE INDICATED.
- ALL FOOD SERVICE EQUIPMENT & BEVERAGE DISPENSING EQUIPMENT SHALL COMPLY WITH NSF REQUIREMENTS, AND REQUIREMENTS OF LOCAL HEALTH DEPARTMENT OFFICIALS HAVING JURISDICTION.
- PROVIDE A SHUTOFF VALVE AT HOT AND/OR COLD WATER SERVICE TO EACH EQUIPMENT ITEM.
- PROVIDE A BACKFLOW PREVENTER HOT AND/OR COLD WATER SERVICE TO EACH EQUIPMENT ITEM (OTHER THAN SINKS) DOWNSTREAM OF SHUT-OFF VALVE. REFERENCE PLUMBING PLAN FOR ADDITIONAL INFORMATION.
- INSTALLATION AND CONNECTION OF ALL FOOD SERVICE EQUIPMENT TO BE PERFORMED BY GENERAL CONTRACTOR UNLESS OTHERWISE INDICATED. ALL SHELVING UNITS SHALL BE ASSEMBLED AND SET IN PLACE BY THE GENERAL CONTRACTOR.
- ALL SINKS PROVIDED BY THE FOOD SERVICE EQUIPMENT SUPPLIER SHALL BE COMPLETE WITH DRAIN TAILPIPE AND FITTINGS. THE GENERAL CONTRACTOR SHALL PROVIDE SHUTOFF VALVES, SUPPLIES AND TRAPS NECESSARY TO CONNECT SUCH SINKS.
- VERIFY ELEC & MECH REQUIREMENTS OF ITEMS NOTED AS BEVERAGE EQUIPMENT (AND NOTED TO BE PROVIDED BY THE OWNER) PRIOR TO INSTALLATION OF SERVICE.

SHEET SYMBOLS

EXX EQUIPMENT TAG - SEE SCHEDULE

EQUIPMENT, FIXTURE & GRAPHIC PLAN

The plan shows the layout of the kitchen area, including the public area, support room, toilet room, and sales area. Equipment is labeled with IDs and descriptions. The plan also shows the location of various fixtures and graphics.

EQUIPMENT SCHEDULE

ID	ITEM	MANUFACTURER	DESCRIPTION	COMMENTS
A01	CUP DISPENSER	VOLLRATH	INC-80	BLACK
A02	PAPER TOWEL DISPENSER	TORK	H5 PEAKSERVE	
A03	SOAP DISPENSER	TORX	S4 SKINCARE	
A06a	FOOD PAN	WEBSTAUANTSTORE		CLEAR POLYCARBONATE
A06b	FOOD PAN	WEBSTAUANTSTORE		CLEAR POLYCARBONATE
A07	TRASH BIN	RUBBERMAID 2957		
A08	FREESTANDING TRASH BIN	RUBBERMAID 9624 DECRS		
A10	6X8 FREEZER STORAGE SHELVING SET	METRO	METROSEAL	METROSEAL COATED
A11a	18" X 36" STORAGE SHELF UNIT	METRO	A1836BR-WITH-86P	STAINLESS STEEL
A11b	18" X 36" STORAGE SHELF UNIT	METRO	A1836BR WITH 86P	STAINLESS STEEL
A11c	18" X 42" STORAGE SHELF UNIT	METRO	A1842BR-WITH-86P	STAINLESS STEEL
A11d	18" X 48" STORAGE SHELF UNIT	METRO	A1848BR WITH 86P	STAINLESS STEEL
A12a	36" OVER SHELVES	SUNFAB	TS14X36GE W/ TWS14GE BRACKET	GREEN EPOXY FINISH
A12b	60" OVER-SHELVES	SUNFAB	TS14X36GE W/ TWS14GE BRACKET	STAINLESS STEEL
A14	WORK TABLE	ADVANCE TABCO	SS-30P	STAINLESS STEEL
A15	2-DWR FILE CAB	FROM OFFICE-MAX OR EQUAL		2-DWR FILE CABINET W/LOCKS
A16	LOCKERS	WINHOLT	WL-55	BEIGE
A17	SAFE	PROVIDED BY OWNERS VENDOR		5 TIER -10"HX12"WX12"D (TOTAL 60"H) EQUIPPED FOR PERSONAL PADLOCKS
A18	TACKBOARD	PROVIDED BY OWNERS VENDOR		PROVIDE ANCHORAGE TO FLOOR, CABINET OR SHELF AS REQ'D.. COORDINATE LOCATION WITH OWNER.
A19	MOP & BROOM HOLDER	RUBBERMAID	HANDLER #1993	
A23a	TIPPING LEDGE (42" LENGTH)			WHITE LAMINATE
A23b	TIPPING LEDGE (36" LENGTH)			WHITE LAMINATE
A24a	18" TABLE BASE	JL CONRAD	TABLE BASE	POWDER COATED BRASS
A24b	ADA TABLE BASE	JL CONRAD		POWDER COATED BRASS
P01	DIPPER WELL	SUMMIT SUPPLY CO INC	PWW-16	STAINLESS STEEL
P02	3-COMPARTMENT SINK	KLINGER'S TRADING	ECS32D	STAINLESS STEEL
P03	DROP IN WASTE SINK	ADVANCED TABCO	DI-1-2012	STAINLESS STEEL
P04	DROP IN HAND SINK	KLINGER'S TRADING	SPDIS-1014	STAINLESS STEEL
P06	WALL-MTD HAND SINK	SUNFAB	SFHSSS-1715	STAINLESS STEEL
P07	MOP SINK	KROWNE	MS-2424	STAINLESS STEEL
P08	WALL-MTD HAND-SINK-ALT	ADVANCE-TABCO	7-P5-22	STAINLESS STEEL
P09	WALL-MTD-HAND-SINK-ALT	ADVANCE-TABCO	7-P5-40	STAINLESS STEEL
P10	3-COMPARTMENT-SINK-ALT	ADVANCE-TABCO	34-3-54-10RL	STAINLESS STEEL
P10	WATER FILTER	HOSHIZAKI	HHS20-G1	10.4" H
P11	DROP-IN ICE-BIN	REGENOV	6000HB1004	STAINLESS STEEL

EQUIPMENT SCHEDULE





ID	ITEM	MANUFACTURER	DESCRIPTION	COMMENTS
P01	DIPPER WELL	SUMMIT SUPPLY CO INC	PWW-16	STAINLESS STEEL
P02	3-COMPARTMENT SINK	KLINGER'S TRADING	ECS32D	STAINLESS STEEL
P03	DROP IN WASTE SINK	ADVANCED TABCO	DI-1-2012	STAINLESS STEEL
P04	DROP IN HAND SINK	KLINGER'S TRADING	SPDIS-1014	STAINLESS STEEL
P06	WALL-MTD HAND SINK	SUNFAB	SFHSSS-1715	STAINLESS STEEL
P07	MOP SINK	KROWNE	MS-2424	STAINLESS STEEL
P08	WALL-MTD HAND-SINK-ALT	ADVANCE-TABCO	7-P5-22	STAINLESS STEEL
P09	WALL-MTD-HAND-SINK-ALT	ADVANCE-TABCO	7-P5-40	STAINLESS STEEL
P10	3-COMPARTMENT-SINK-ALT	ADVANCE-TABCO	34-3-54-10RL	STAINLESS STEEL
P10	WATER FILTER	HOSHIZAKI	HHS20-G1	10.4" H
P11	DROP-IN ICE-BIN	REGENOV	6000HB1004	STAINLESS STEEL


EQUIPMENT SCHEDULE

ID	ITEM	MANUFACTURER	DESCRIPTION	COMMENTS
P01	DIPPER WELL	SUMMIT SUPPLY CO INC	PWW-16	STAINLESS STEEL
P02	3-COMPARTMENT SINK	KLINGER'S TRADING	ECS32D	STAINLESS STEEL
P03	DROP IN WASTE SINK	ADVANCED TABCO	DI-1-2012	STAINLESS STEEL
P04	DROP IN HAND SINK	KLINGER'S TRADING	SPDIS-1014	STAINLESS STEEL
P06	WALL-MTD HAND SINK	SUNFAB	SFHSSS-1715	STAINLESS STEEL
P07	MOP SINK	KROWNE	MS-2424	STAINLESS STEEL
P08	WALL-MTD HAND-SINK-ALT	ADVANCE-TABCO	7-P5-22	STAINLESS STEEL
P09	WALL-MTD-HAND-SINK-ALT	ADVANCE-TABCO	7-P5-40	STAINLESS STEEL
P10	3-COMPARTMENT-SINK-ALT	ADVANCE-TABCO	34-3-54-10RL	STAINLESS STEEL
P10	WATER FILTER	HOSHIZAKI	HHS20-G1	10.4" H
P11	DROP-IN ICE-BIN	REGENOV	6000HB1004	STAINLESS STEEL

EQUIPMENT SCHEDULE

ID	ITEM
----	------

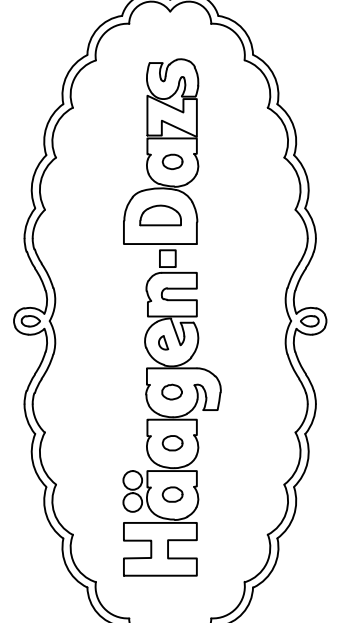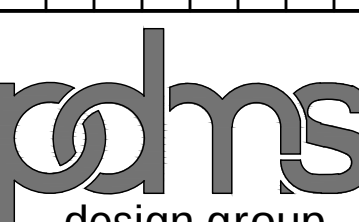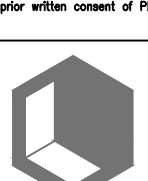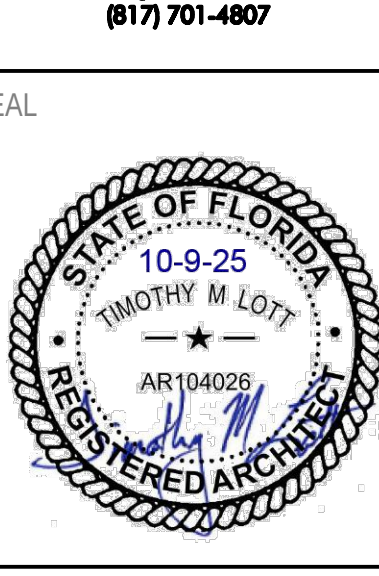
											
STORE #1436 40 S MAGNOLIA AVE. OCALA, FL 34470											
											DESIGNER
											DATE
											REVISIONS
											NO.
 pdms design group Architecture + Engineering 2225 East Rondol Mill Road, Suite #300 Arlington, Texas 76011 817-633-4200 This document contains information proprietary to PDMS Design Group and is furnished in confidence for the limited purpose of evaluation, bidding, review, or construction. This document or its contents may not be used for any other purpose and may not be reproduced or disclosed to others without the prior written consent of PDMS Design Group.											
 TIMOTHY M. LOTT AIA, NCARB 2225 E Rondol Mill Rd, Suite 300 Arlington, TX 76011 (817) 701-4807											
SEAL 											
Project No.						250219					
Scale						AS NOTED					
Drawn						EL					
Checked						CF					
Date						10/09/25					
Drawing Title											
REFLECTED CEILING PLAN											
Drawing No.						A200					

 [illegible]

This document contains information proprietary to PDMS Design Group and is furnished in confidence for the limited purpose of evaluation, bidding, review, or construction. This document or its contents may not be used for any other purpose and may not be reproduced or disclosed to others without the prior written consent of PDMS Design Group.




SEAL

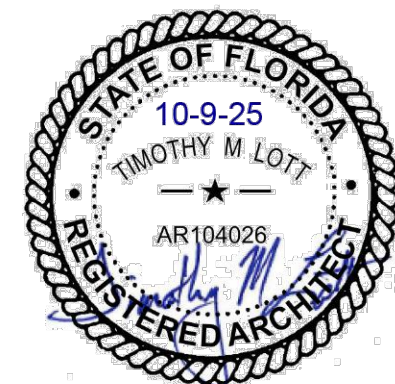


Project No.	250219
Scale	AS NOTED
Drawn	EL
Checked	CF
Date	10/09/25

STOREFRONT ELEVATION & DETAILS

Drawing No. **A300**

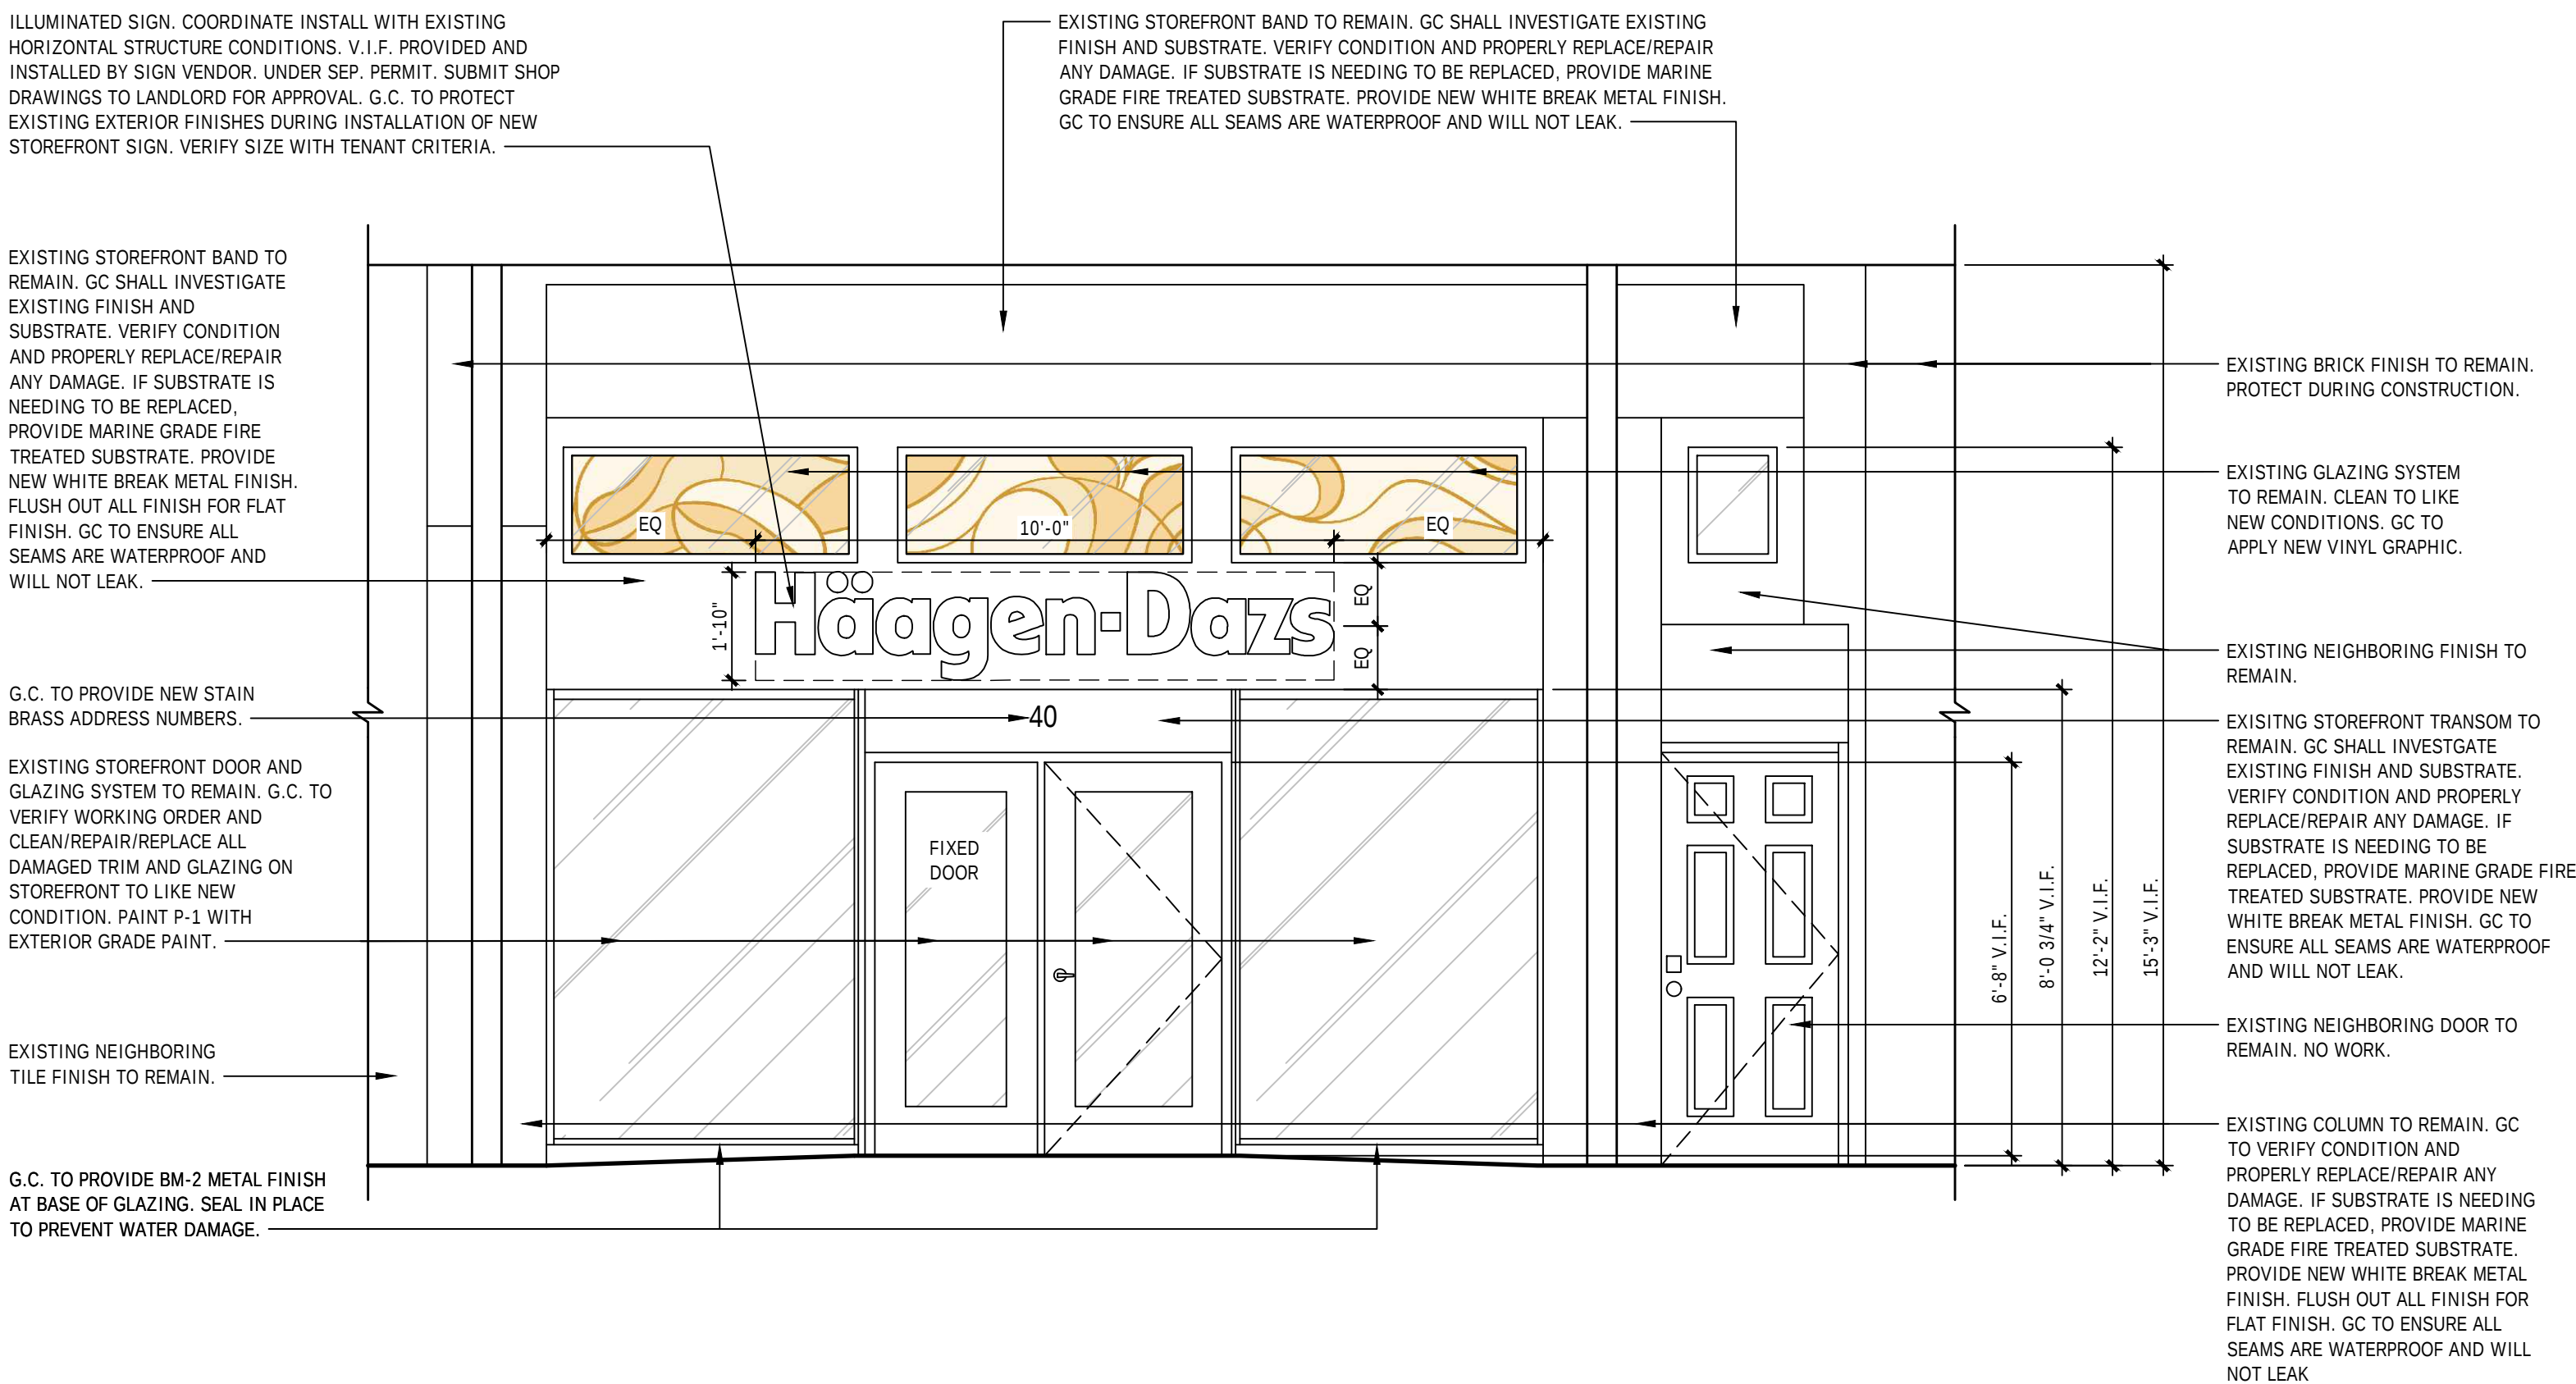


1	EXTERIOR STOREFRONT ELEVATION
8" = 1'-0"	

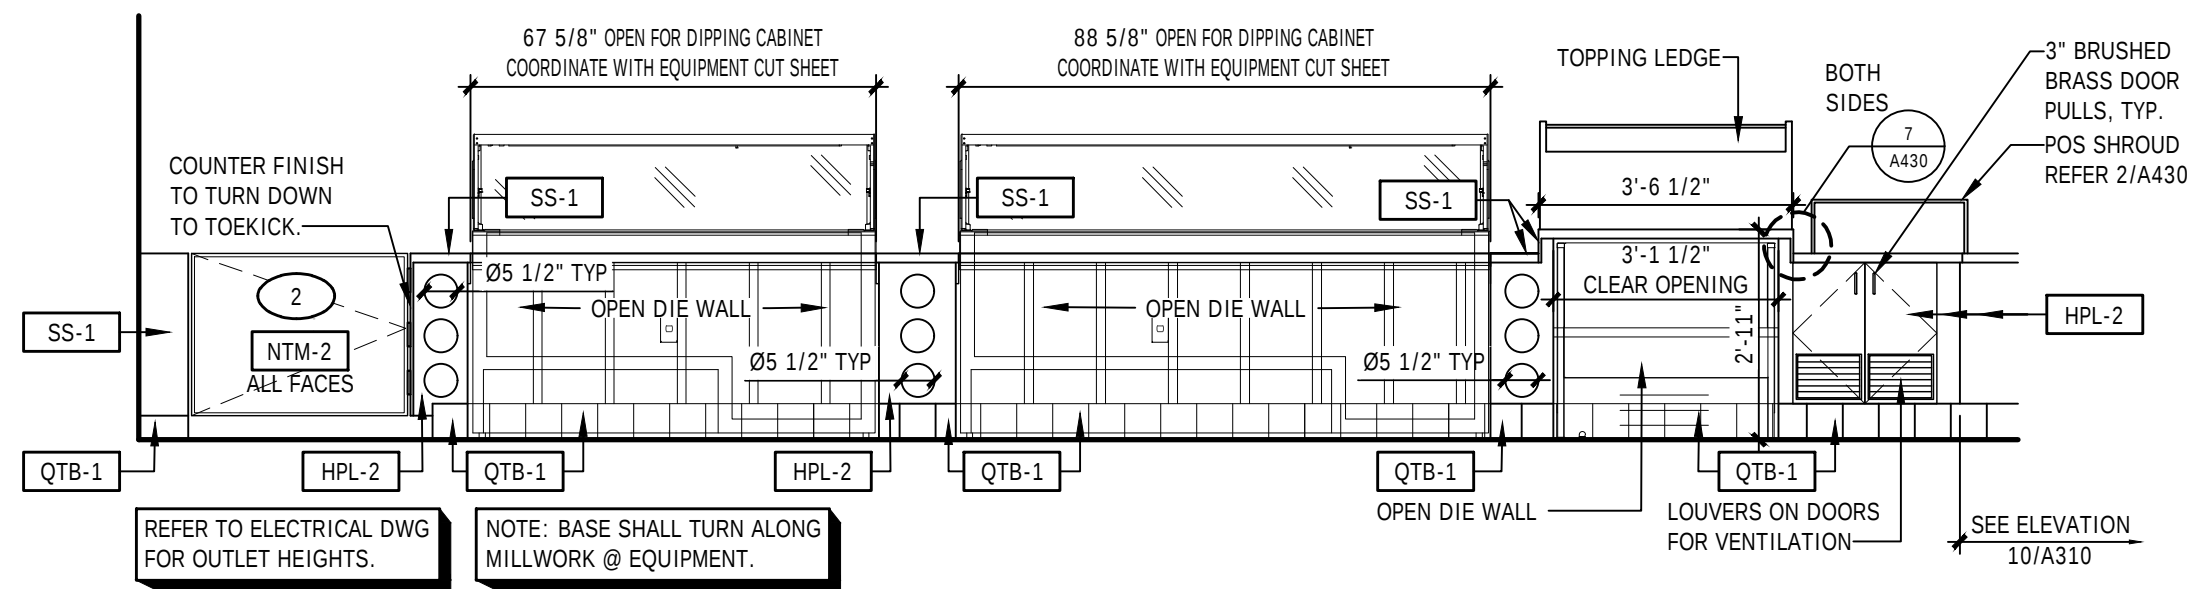


11	INTERIOR ELEVATION
----	--------------------

3/8"=1'-0" @ BACKSIDE OF FRONTLINE

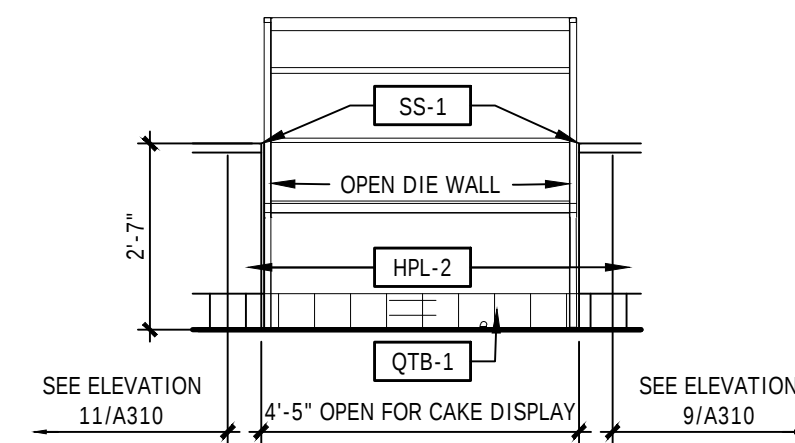


10	INTERIOR ELEVATION
----	--------------------

3/8"=1'-0"	@ BACKSIDE OF FRONTLINE
------------	-------------------------

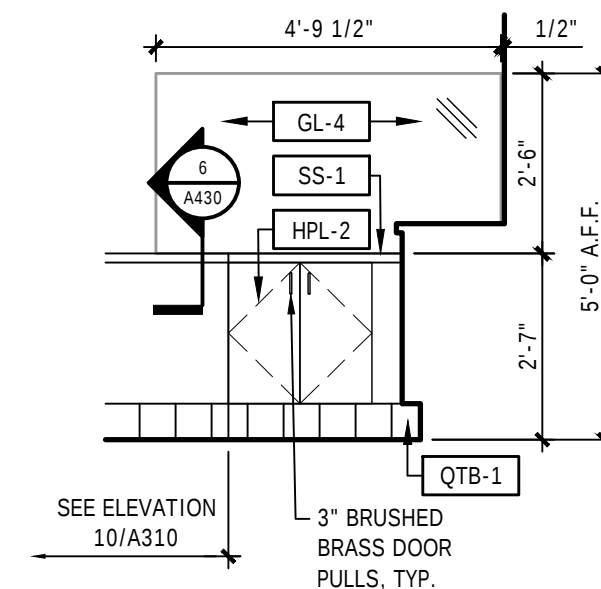


9	INTERIOR ELEVATION
---	--------------------

3/8"=1'-0"	@ BACKSIDE OF FRONTLINE
------------	-------------------------

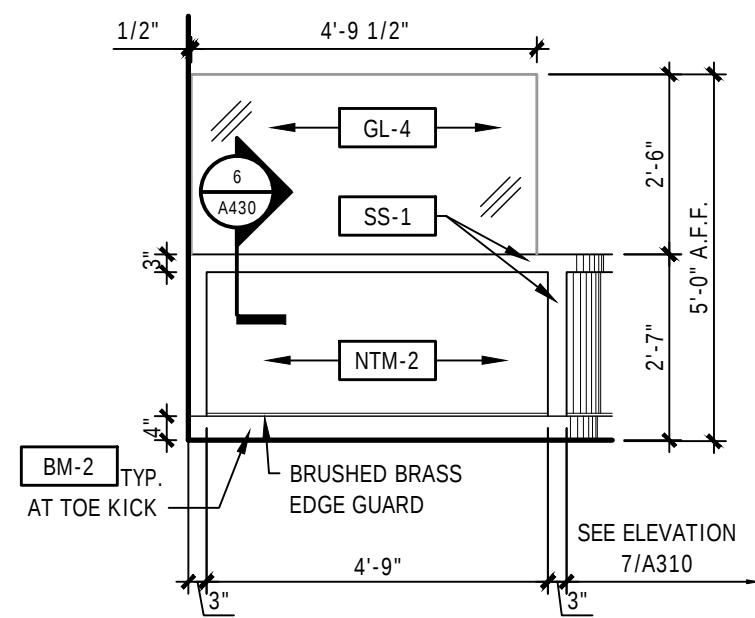


NOTE: THERE SHALL BE NO VISIBLE SPACE JOINTS IN NTM-2 FINISH. JOINTS SHALL OCCUR AT SS-1 WATERFALLS ONLY.

8	INTERIOR ELEVATION
---	--------------------
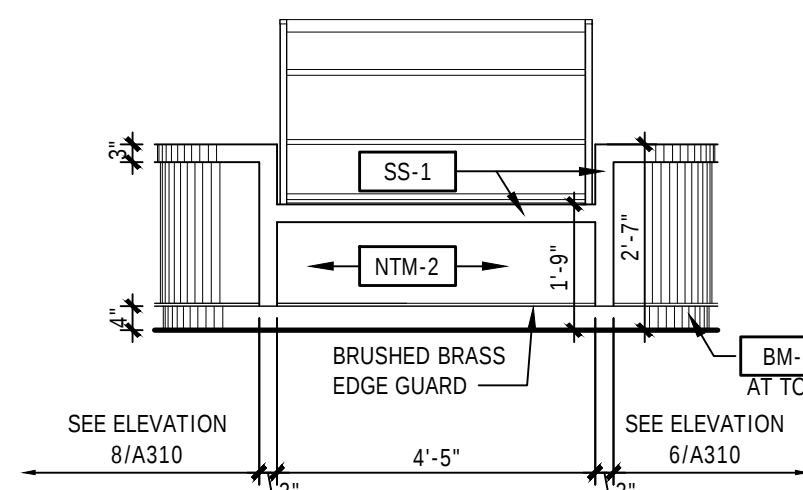
$$\frac{3}{8}'' = 1'-0''$$


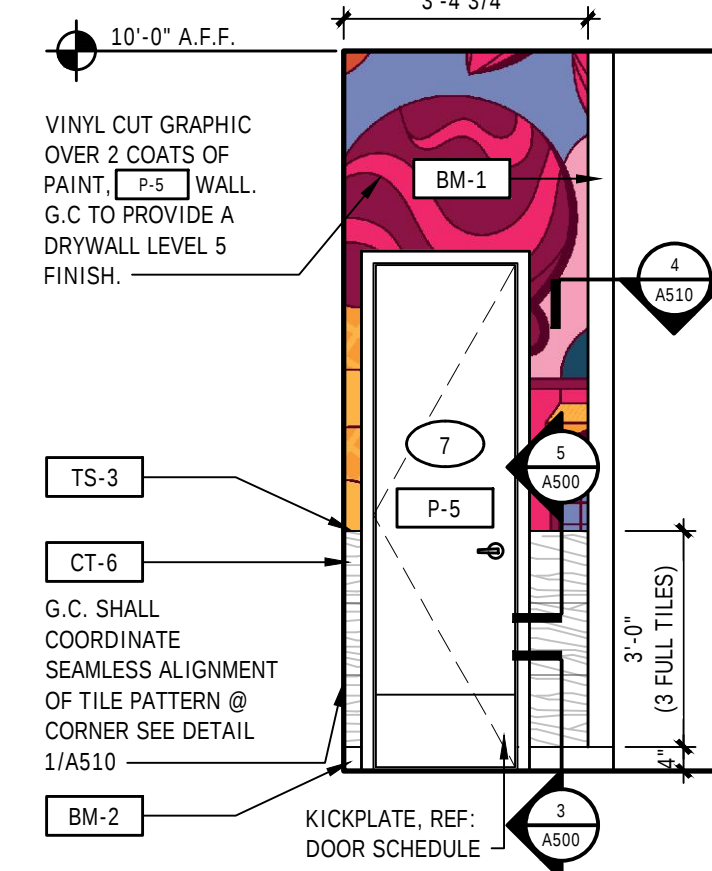
NOTE: THERE SHALL BE NO VISIBLE SPACE JOINTS IN NTM-2 FINISH. JOINTS SHALL OCCUR AT SS-1 WATERFALLS ONLY.

7	INTERIOR ELEVATION
---	--------------------
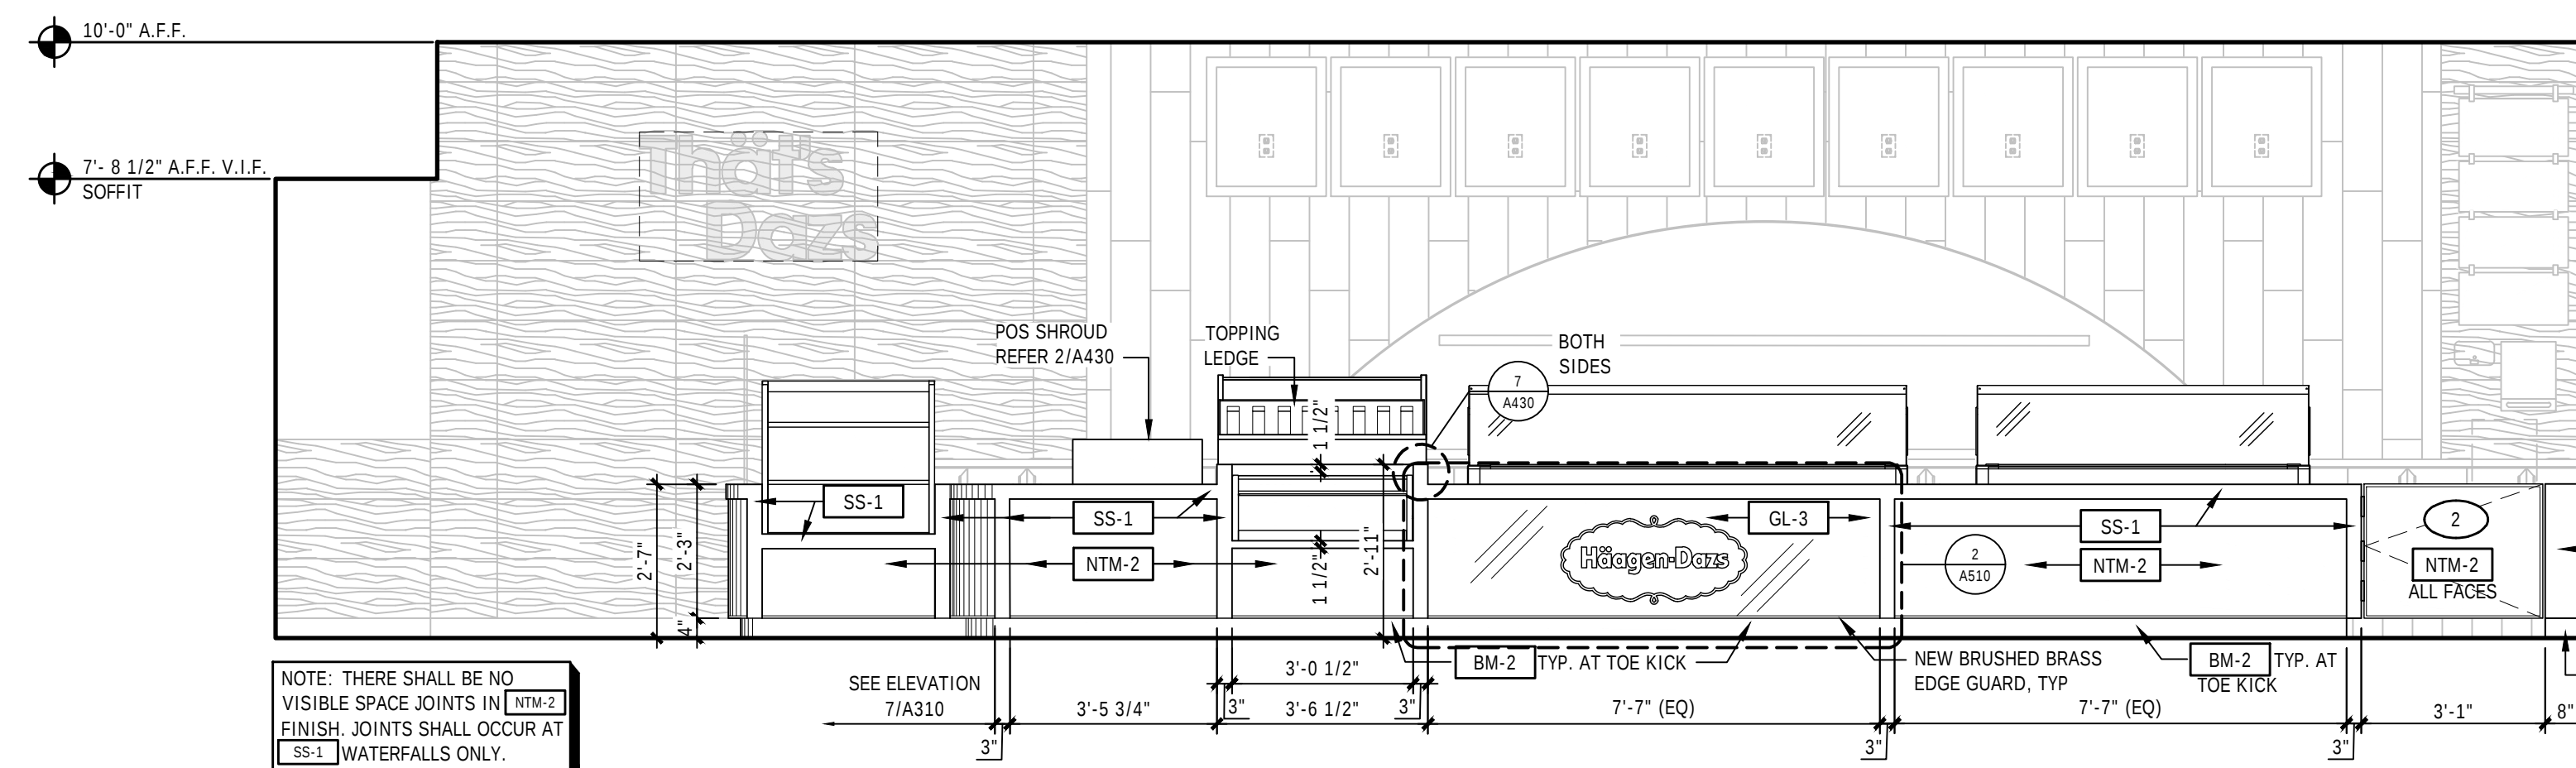
$$3/8" = 1'-0"$$


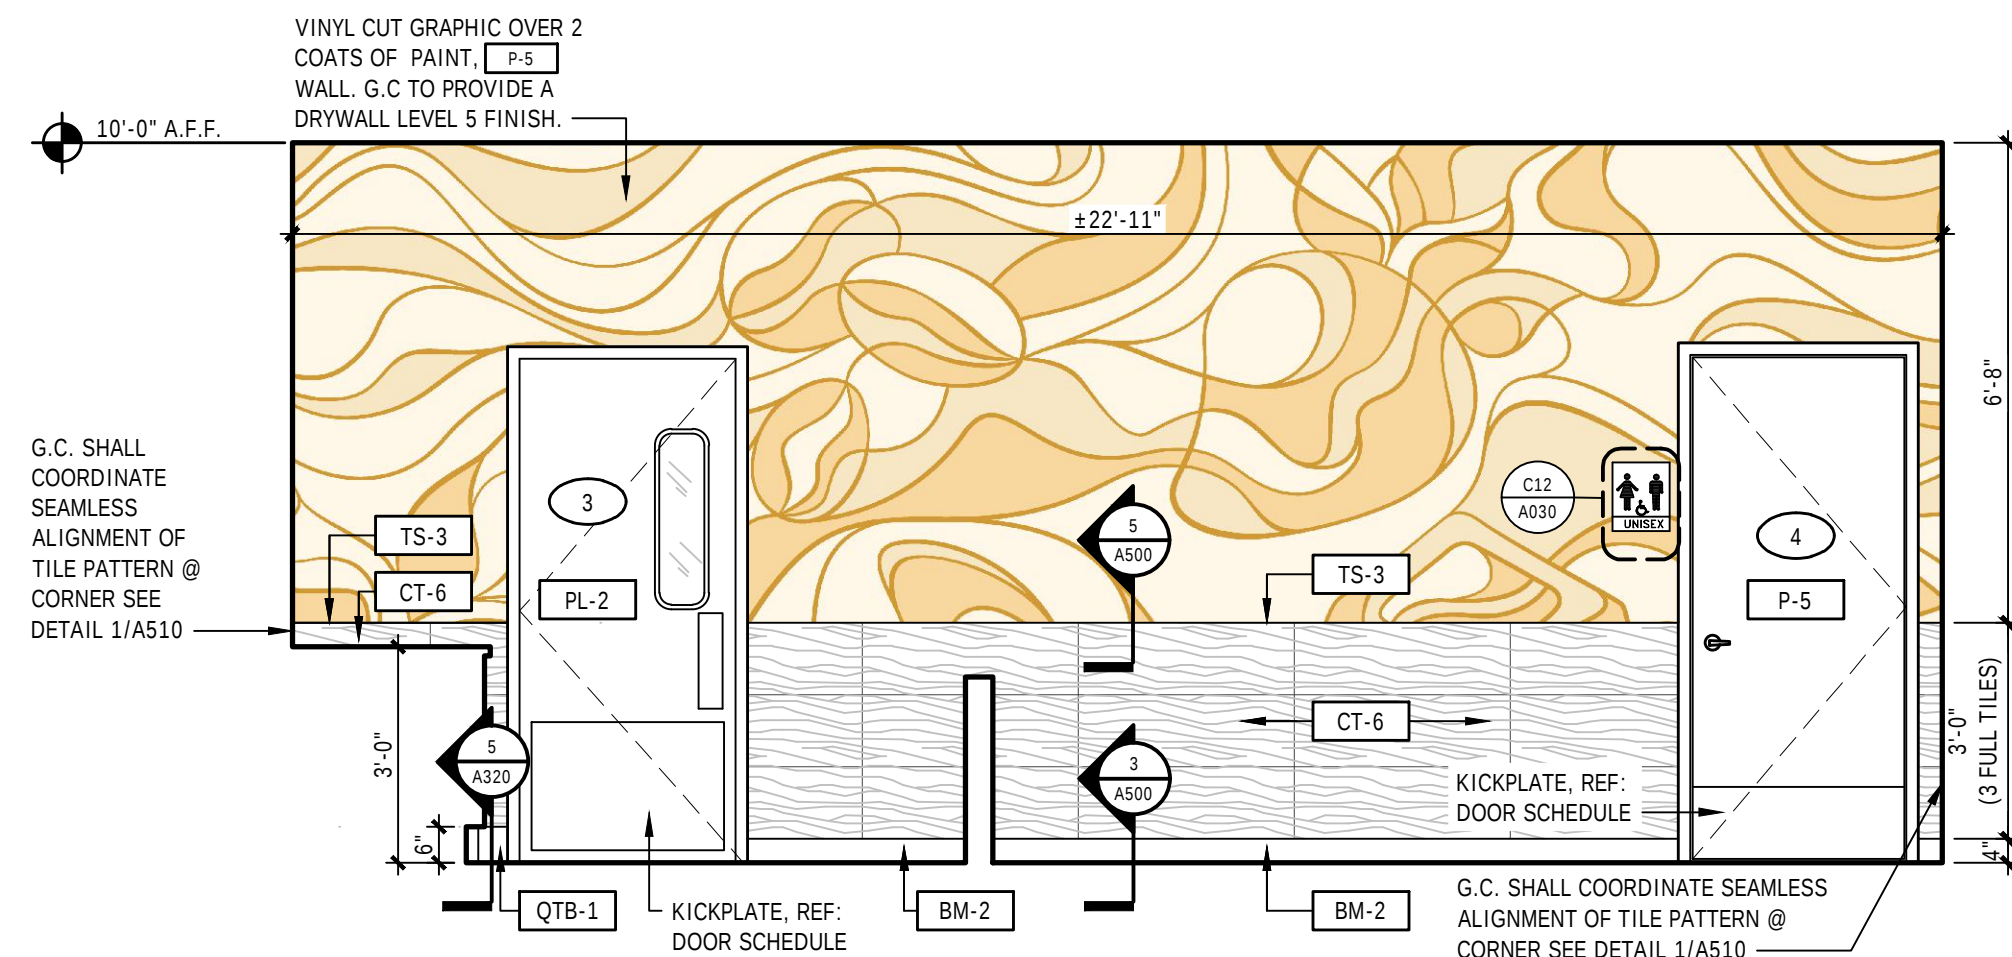
NOTE: THERE SHALL BE NO
VISIBLE SPACE JOINTS IN NTM-2
FINISH. JOINTS SHALL OCCUR AT
SS-1 WATERFALLS ONLY.

6	INTERIOR ELEVATION
---	--------------------


$$3/8'' = 1' - 0$$


5	INTERIOR ELEVATION
---	--------------------

3/8"=1'-0" @ SIDE OF BRANDWALL




4	INTERIOR ELEVATION
---	--------------------

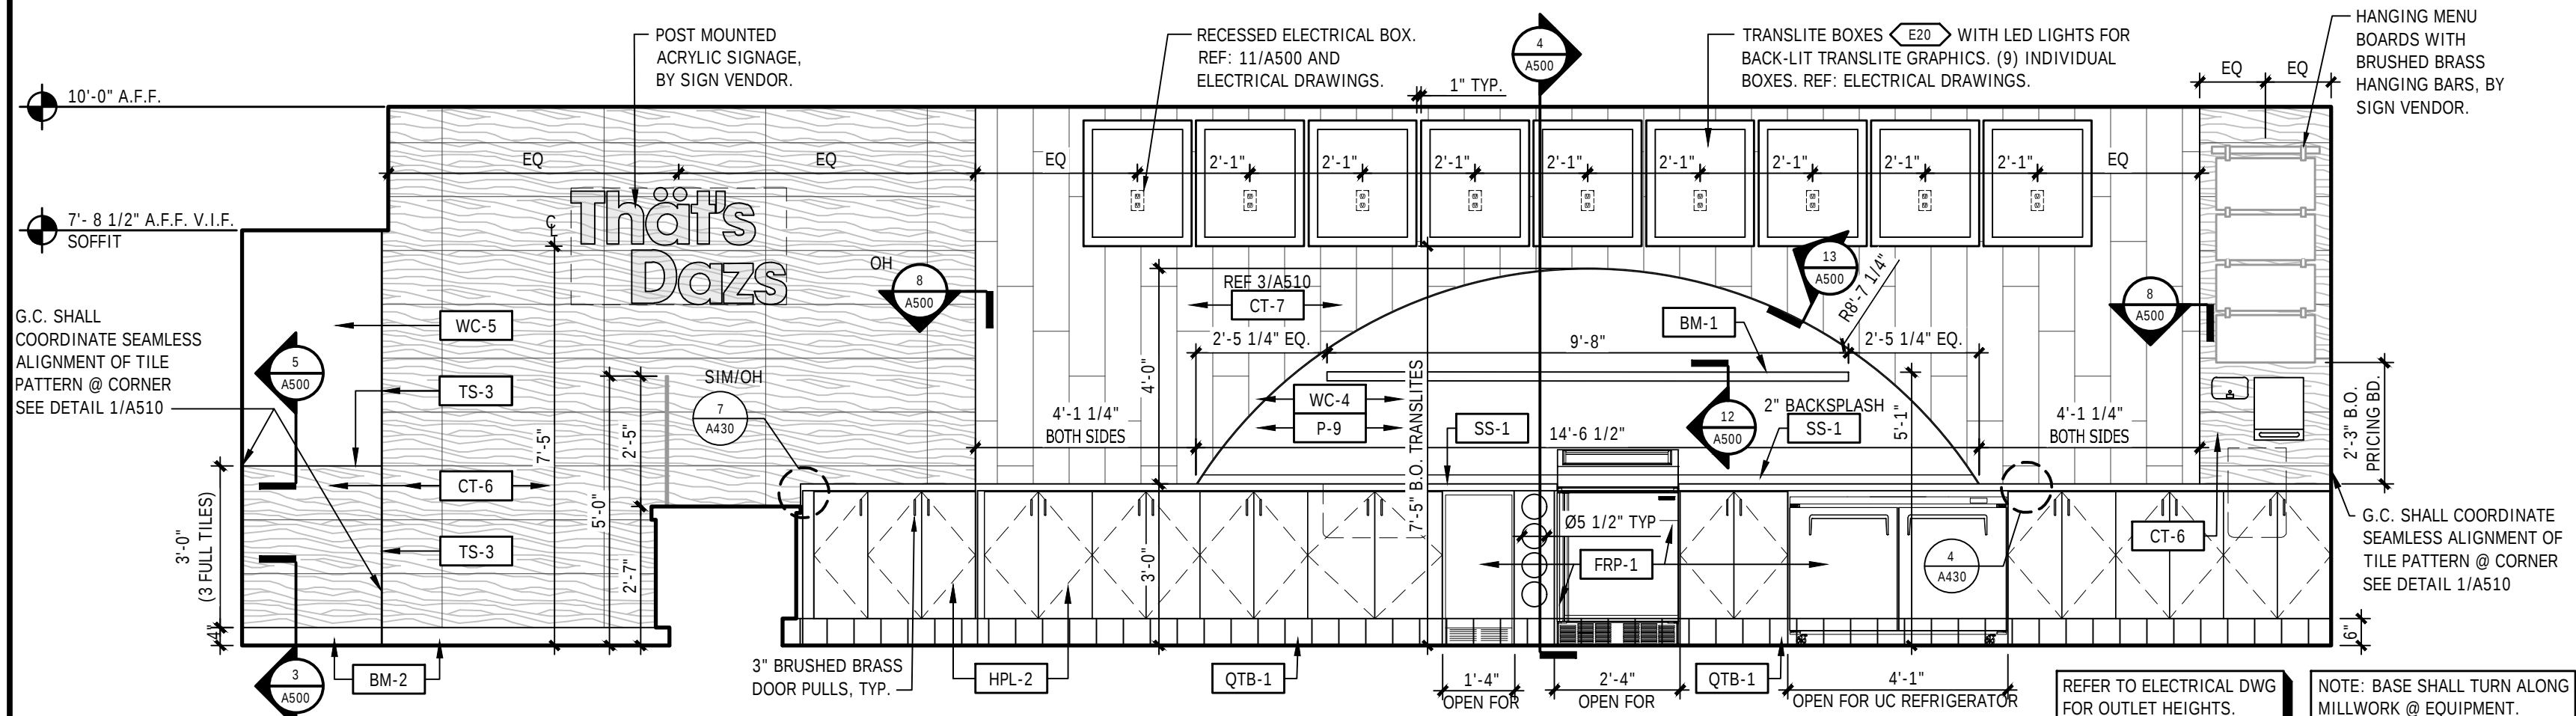
$$3/8'' = 1'-0''$$


3	INTERIOR ELEVATION
---	--------------------

1/8"=1'-0" @ FIXTURE BACKLINE

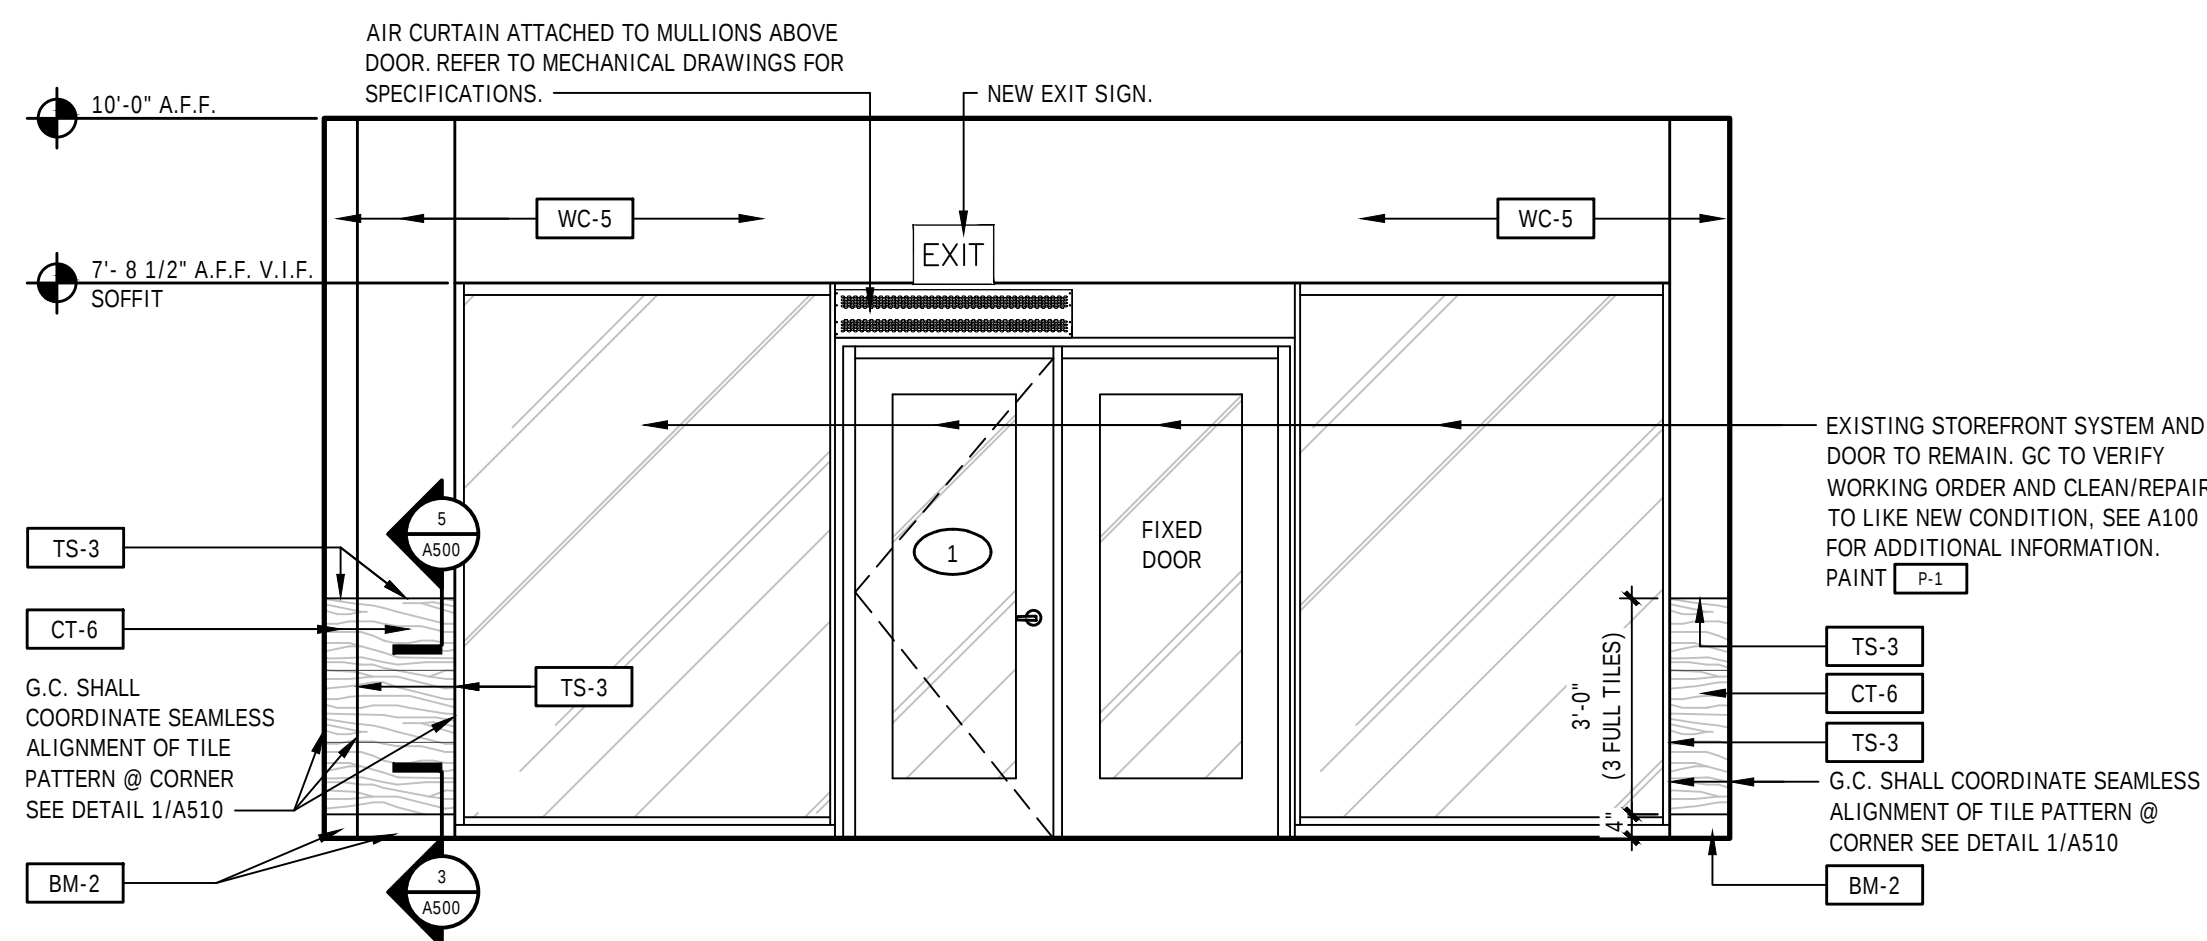


2	INTERIOR ELEVATION
---	--------------------
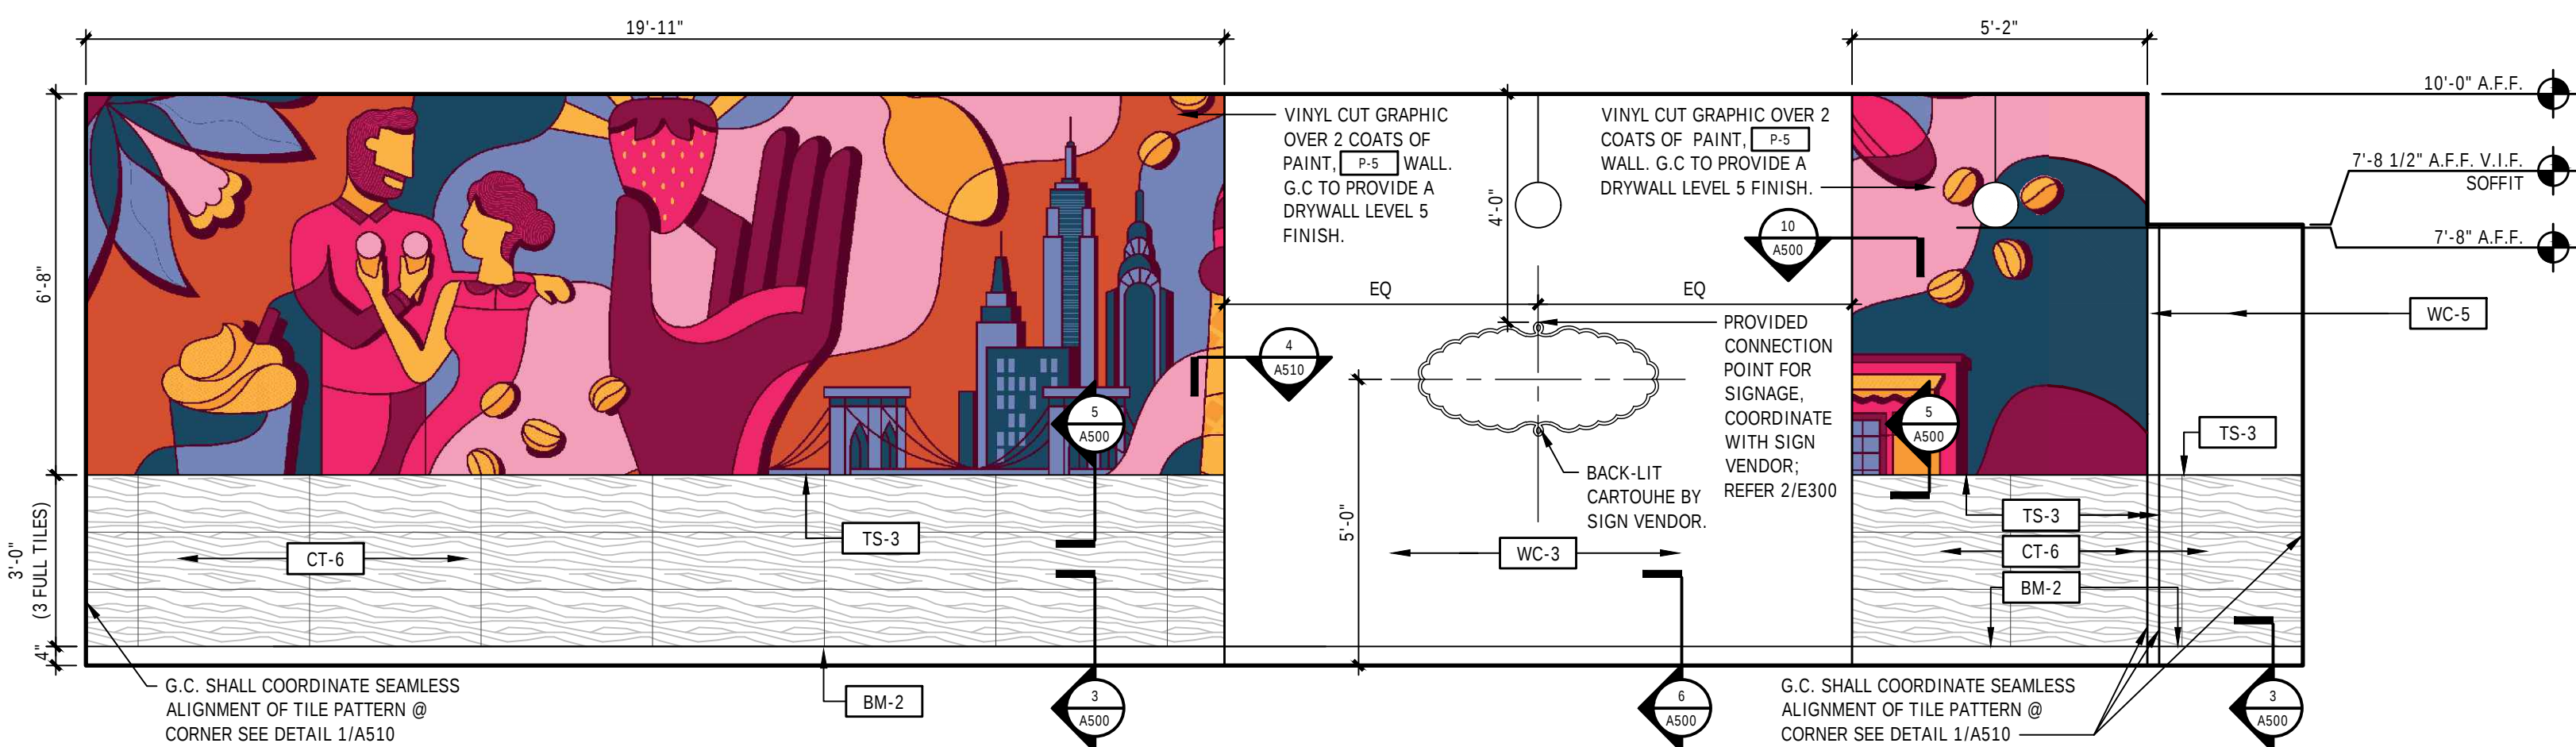
$$3/8" = 1'-0"$$


1	INTERIOR ELEVATION
---	--------------------

1/8"=1'-0" @ BRANDWALL

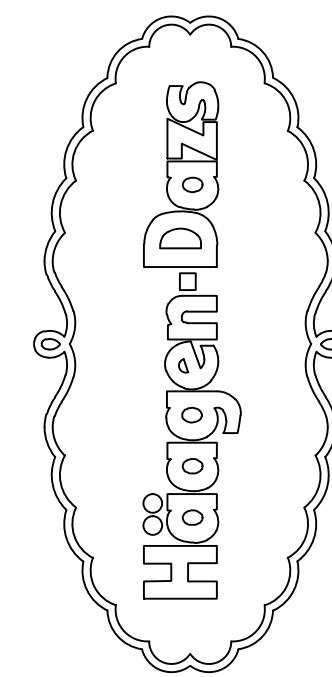

STORE #1436
40 S MAGNOLIA AVE.
OCALA, FL
34470

[illegible]






TIMOTHY M. LOTT
AIA, NCARB
2225 E Randol Mill Rd, Suite 300
Arlington, TX 76011
(817) 701-4807



Project No.	250219
Scale	AS NOTED
Drawn	EL
Checked	CF
Date	10/09/25
Drawing Title	

INTERIOR ELEVATIONS

Drawing No.	A310
-------------	-------------

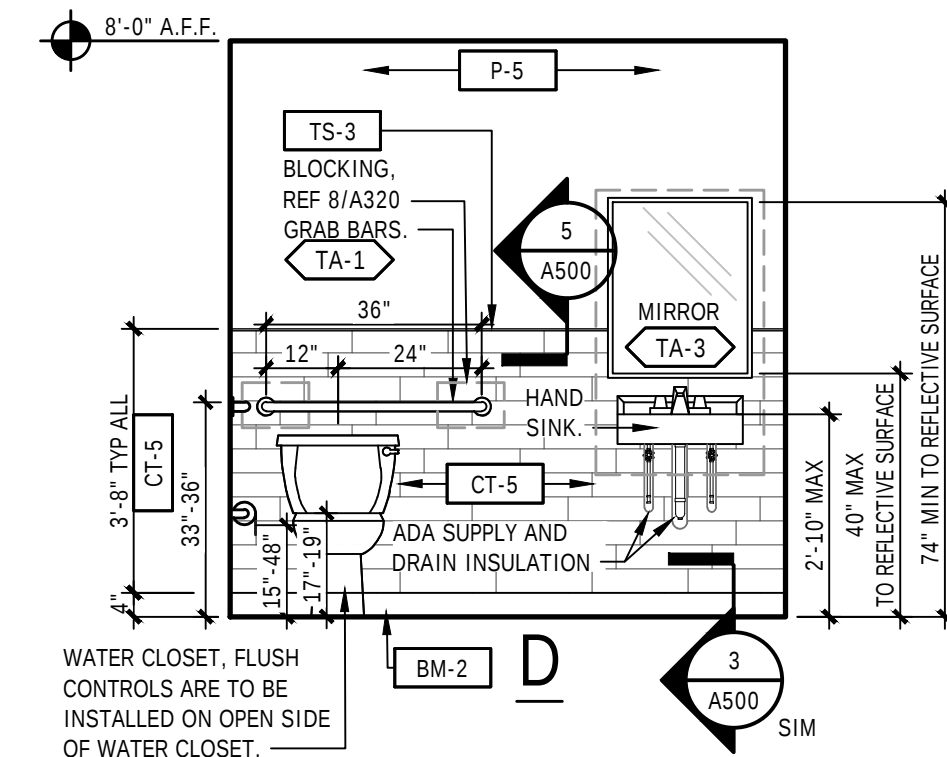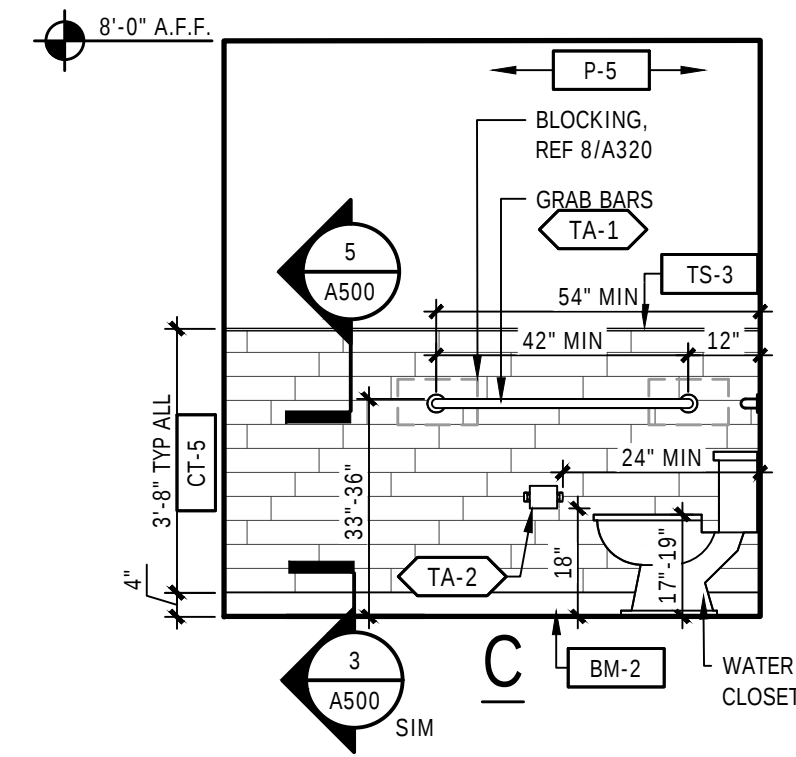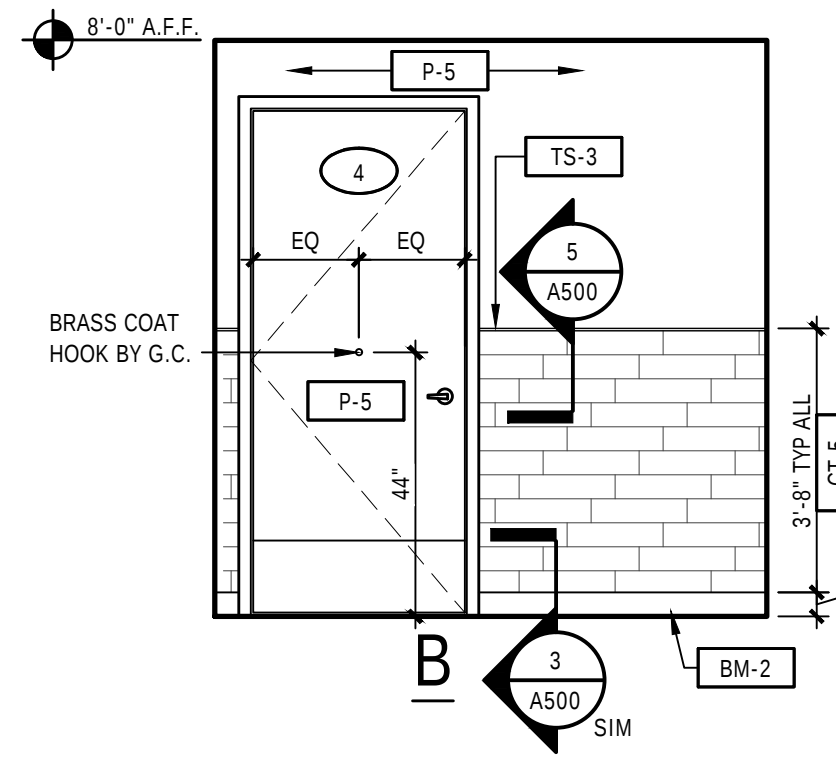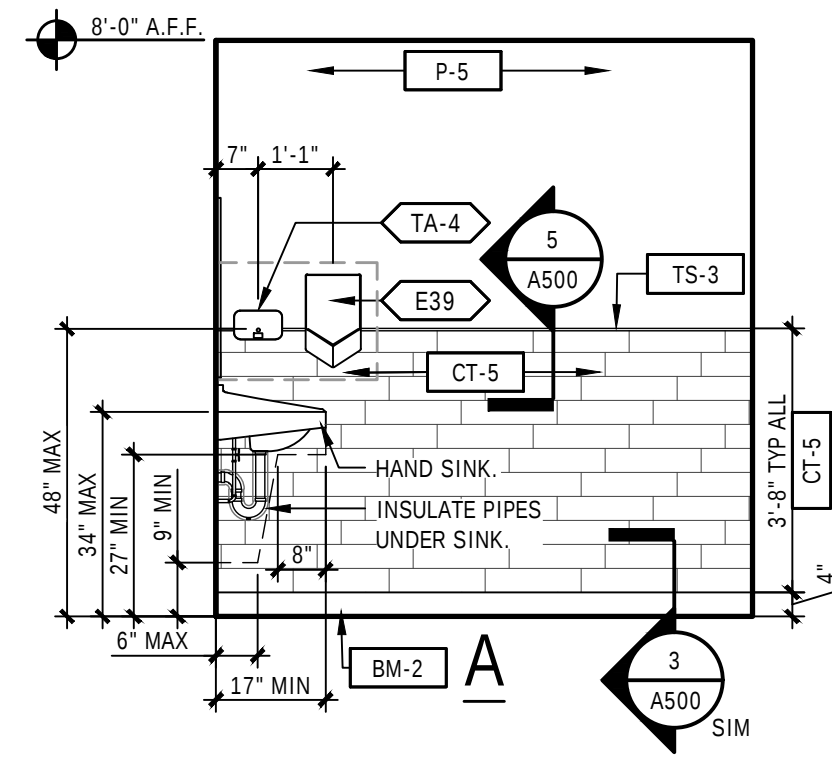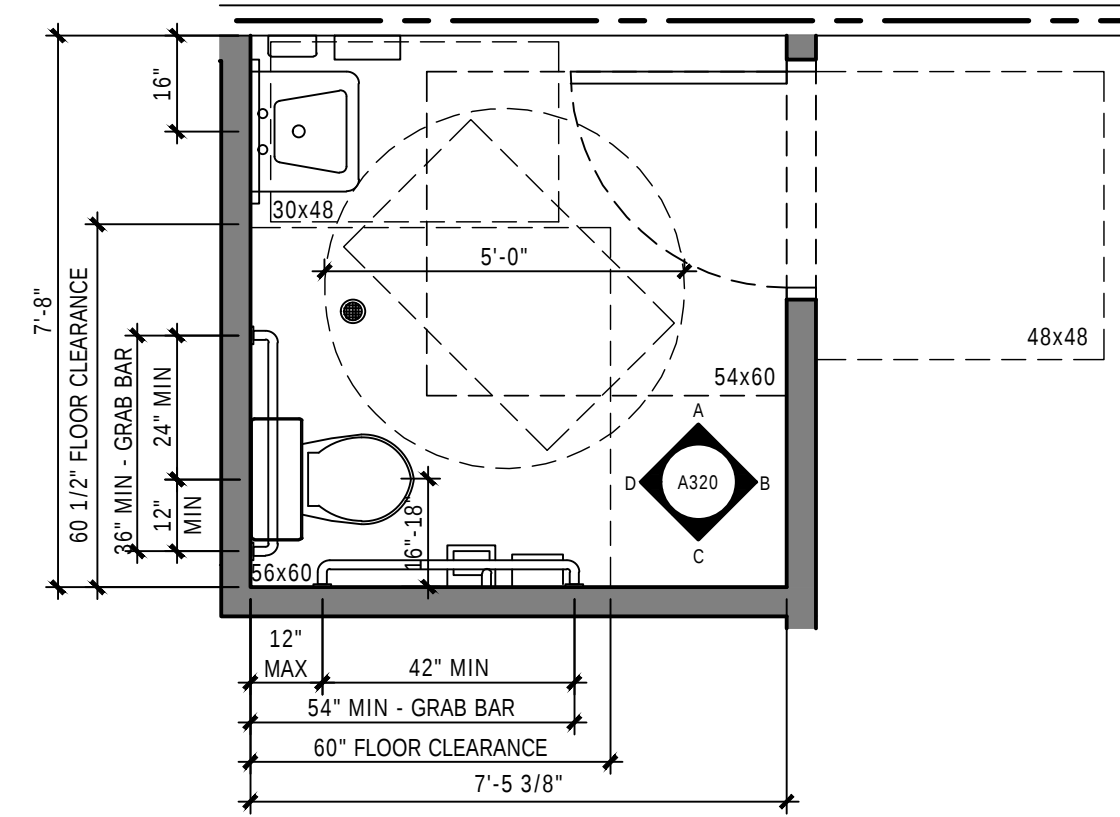

MARK	DESCRIPTION	REMARKS
TA-1	BOBRICK #8-6806 X 36 #8-6806 X 48 - 1 1/2" DIA. STAINLESS STEEL GRAB BAR	STAINLESS STEEL, SATIN FINISH W/ SNAP FLANGE MOUNTING PROVIDE WALL BLOCKING
TA-2	BOBRICK #8-2840 (DOUBLE ROLL) TOILET PAPER DISPENSER W/ 16" X 5" ACCESSORY SHELF	STAINLESS STEEL, SATIN FINISH PROVIDE WALL BLOCKING
TA-3	BOBRICK #8-293 2436 ANSI TILT MIRROR - 24" X 36"	STAINLESS STEEL, SATIN FINISH PROVIDE WALL BLOCKING
TA-4	TORX 54 SKINCARE SOAP DISPENSER	SURFACE MOUNTED PROVIDE WALL BLOCKING
E39	DYSON AIRBLADE® #HU02 HAND DYER	STAINLESS STEEL, STAIN FINISH PROVIDE WALL BLOCKING


NOTE: ALL ACCESSORIES LISTED ABOVE TO BE SUPPLIED AND
INSTALLED BY GENERAL CONTRACTOR AND MAY BE
SUBSTITUTED WITH APPROVED EQUALS OR PER LOCAL CODES.

9	TOILET ROOM PLAN & ELEVATIONS
---	-------------------------------

3/8"=1'-0"	@ SUPPORT ROOM
ANCHOR PLATES ARE 12 GAUGE STEEL AND 6" WIDE. (LENGTH VARIES). FURNISHED WITH STAINLESS STEEL MACHINE SCREWS TO ACCOMMODATE WALL FINISHES TO 1 1/2" THICK. ANCHOR PLATES SECURED TO STUDS BY WELDING, WIRING OR SELF THREADING SCREWS.	

GRAB BARS

- LOCATE GRAB BARS AS NOTED IN RESTROOM ELEVATIONS
- THE DIAMETER OR WIDTH OF THE GRIPPING SURFACE IS REQUIRED TO BE 1 1/4" TO 1 1/2" 32 MM - 38 MM, OR THE SHAPE IS TO PROVIDE AN EQUIVALENT GRIPPING SURFACE. IF GRAB BARS ARE MOUNTED ADJACENT TO A WALL, THE SPACE BETWEEN THE WALL AND THE GRAB BARS IS TO BE 1 1/2" 38 MM.
- GRAB BARS SHALL NOT ROTATE WITHIN THEIR FITTINGS.
- GRAB BARS AND ANY SURFACE ADJACENT TO THEM CAN NOT HAVE ANY SHARP OR ABRASIVE ELEMENTS. EDGES ARE TO HAVE A MINIMUM RADIUS OF 1/8 INCH.
- BENDING STRESS IN A GRAB BAR OR SEAT INDUCED BY THE MAX. BENDING MOMENT FROM THE APPLICATION OF A 250 LB. POINT LOAD SHALL BE LESS THAN THE ALLOWABLE STRESS FOR THE MATERIAL OF THE GRAB BAR OR SEAT.
- SEAR STRESS INDUCED IN A GRAB BAR BY THE APPLICATION OF 250 LBF POINT LOAD SHALL BE LESS THAN THE ALLOWABLE SEAR STRESS FOR THE MOUNTING BRACKET OR OTHER SUPPORT IS CONSIDERED TO BE FULLY REINSTALED, THEN DIRECT AND TORSIONAL SHEAR STRESSES SHALL NOT EXCEED THE ALLOWABLE SEAR STRESS.
- SHEAR FORCE INDUCED IN FASTENER OR MOUNTING DEVICES FROM THE APPLICATION OF A 250 LB. POINT LOAD SHALL BE LESS THAN THE ALLOWABLE LATERAL LOAD OF EITHER FASTENER OR MOUNTING DEVICE OR THE SUPPORTING STRUCTURE, WHICHEVER HAS THE SMALLER ALLOWABLE LOAD.
- TENSION FORCE INDUCED IN A FASTENER BY A DIRECT TENSION FORCE OF A 250 LB. POINT LOAD, PLUS THE MAX. MOMENT FROM THE APPLICATION OF A 250 LB. POINT LOAD, SHALL BE LESS THAN THE ALLOWABLE WITHDRAWAL LOAD BETWEEN THE FASTENER AND SUPPORTING STRUCTURE.
- GRAB BAR AND ANY WALL OR OTHER SURFACE ADJACENT TO IT SHALL BE FREE OF ANY SHARP OR ABRASIVE ELEMENTS. EDGES SHALL HAVE A MINIMUM RADIUS OF 1/8".

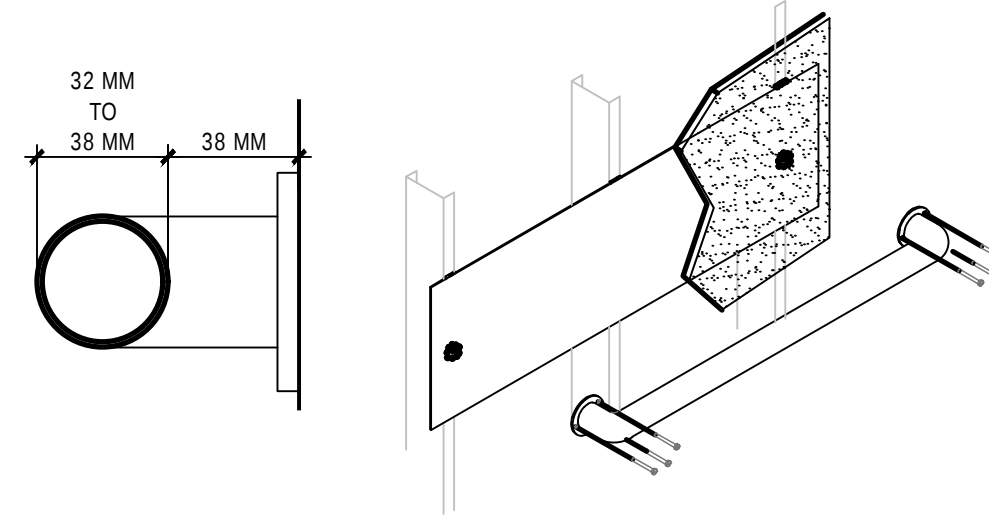

8	GRAB BAR DETAIL
---	-----------------

	N.T.S.
--	--------

NOT USED



$$1-1/2"=1'-0"$$

NOT USED

 $1-1/2"=1'-0"$


COVE BASE DETAIL

3"=1'-0"	@ QUARRY TILE 3/8" RADIUS CORNERS
----------	-----------------------------------

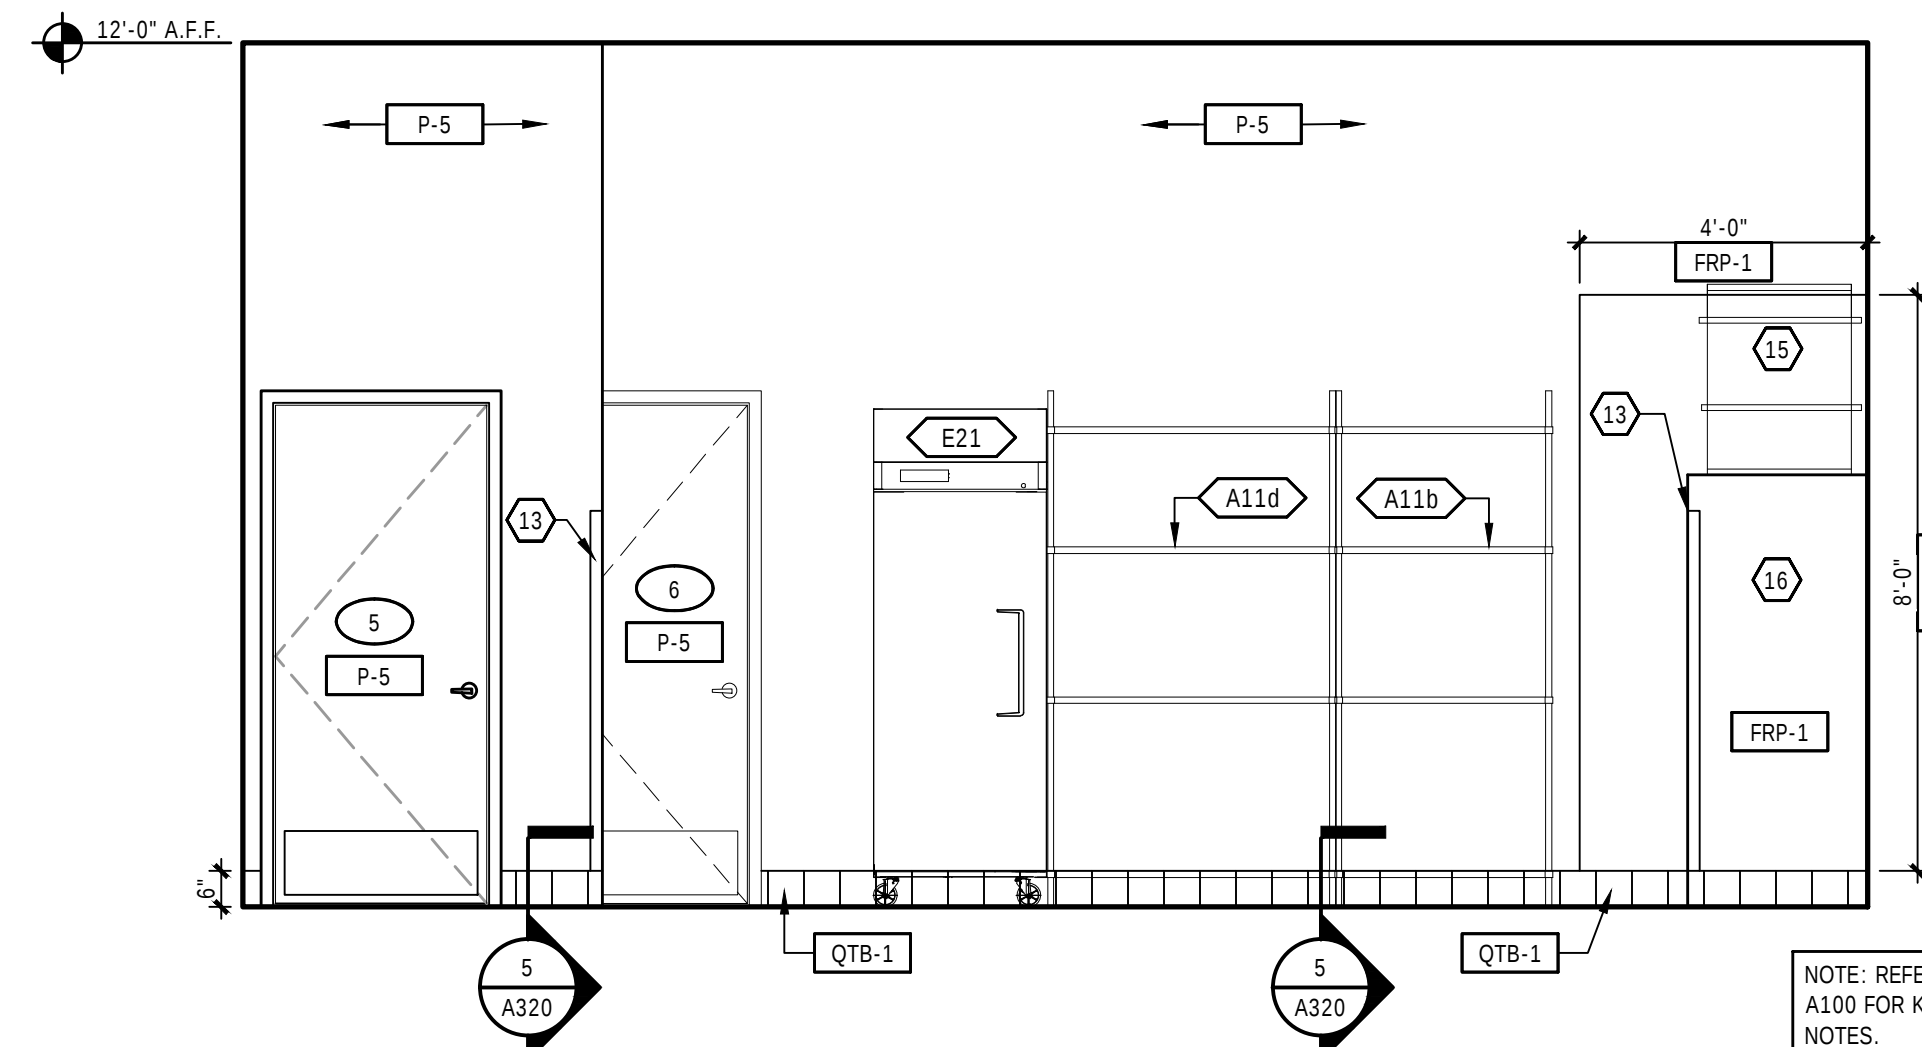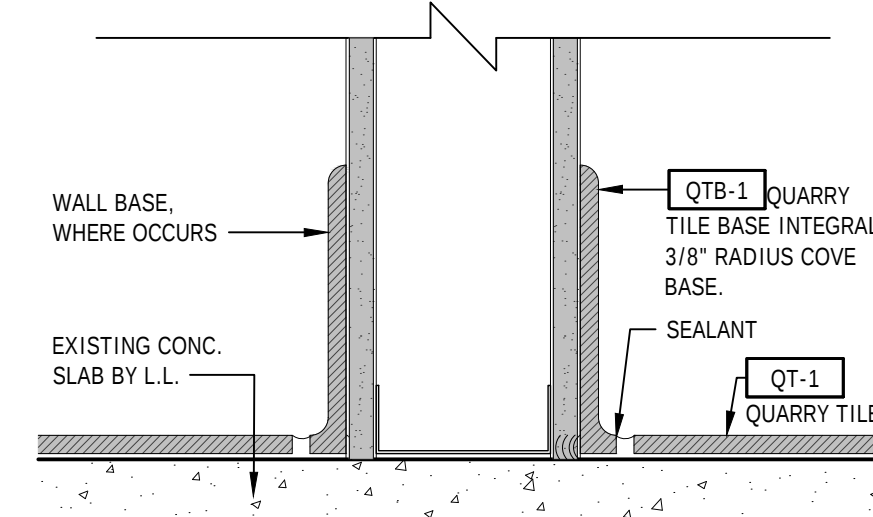


4	INTERIOR ELEVATION
---	--------------------

3/8"=1'-0"	@SUPPORT ROOM
------------	---------------

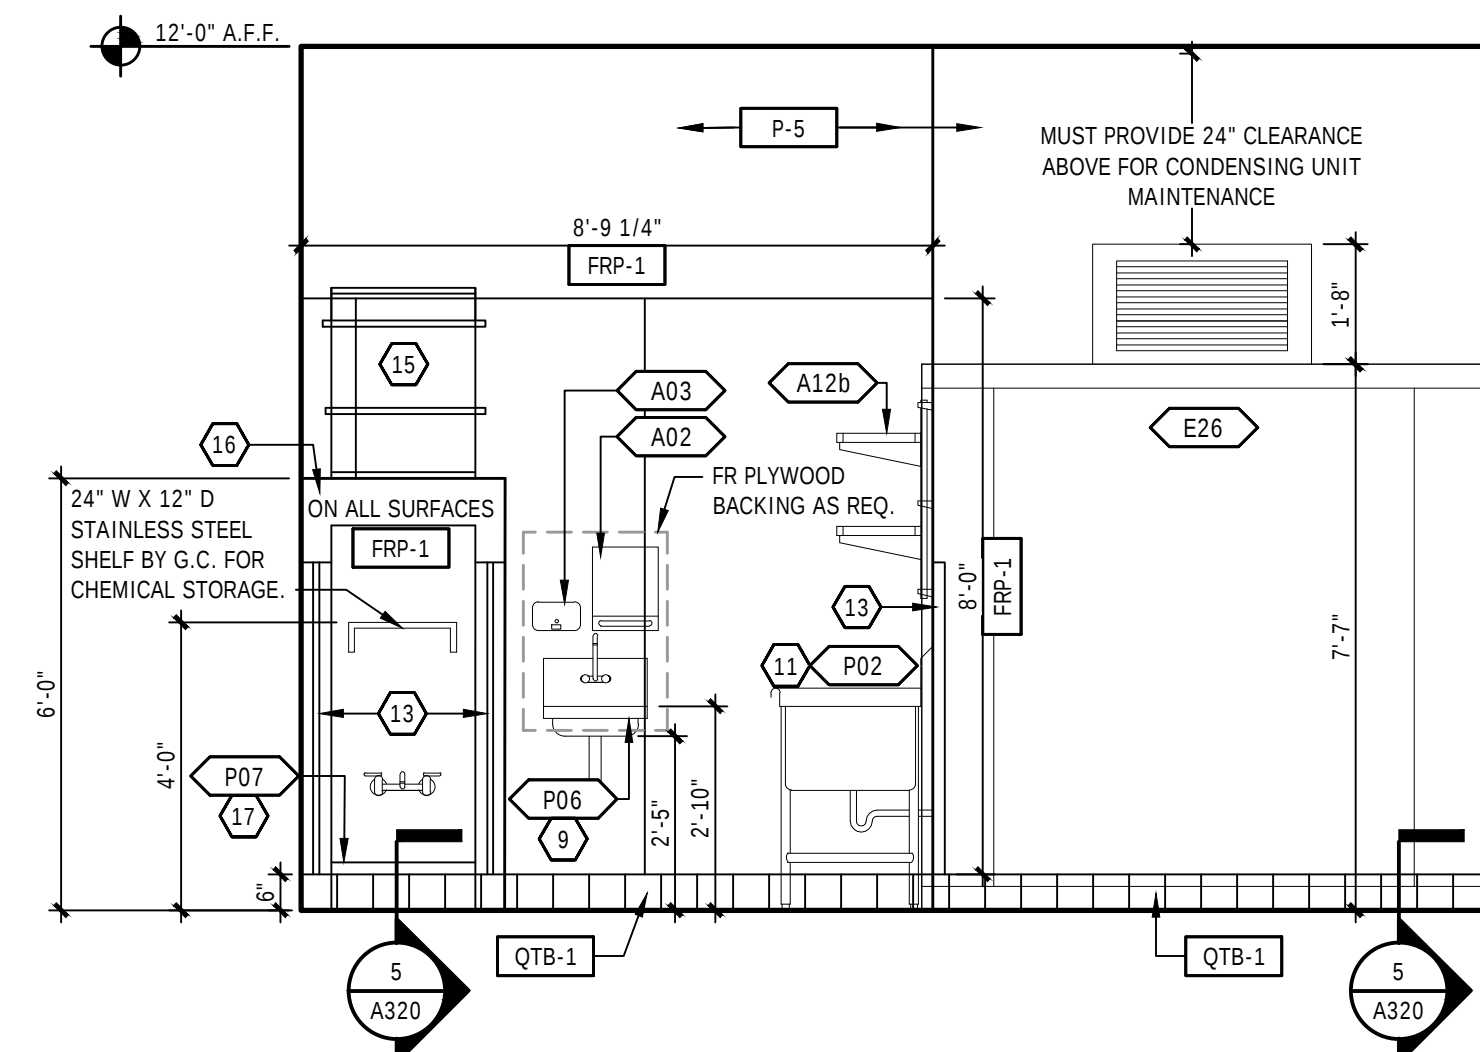


2	INTERIOR ELEVATION
---	--------------------

3/8"=1'-0"	@SUPPORT ROOM
------------	---------------

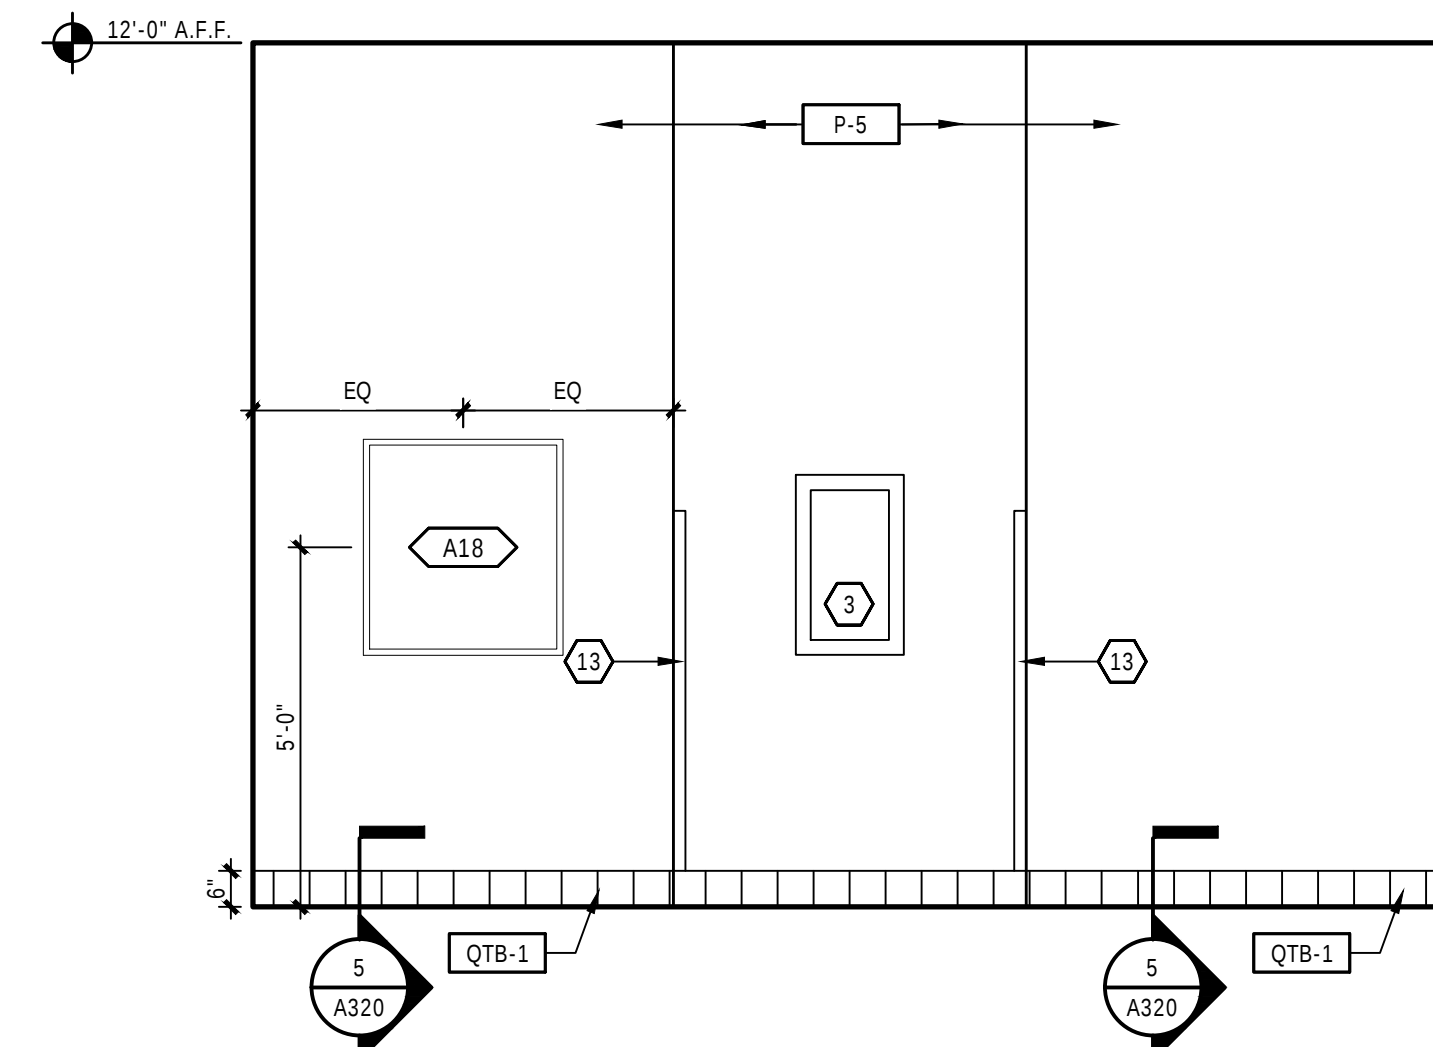


3	INTERIOR ELEVATION
---	--------------------

3/8"=1'-0"	@SUPPORT ROOM
------------	---------------

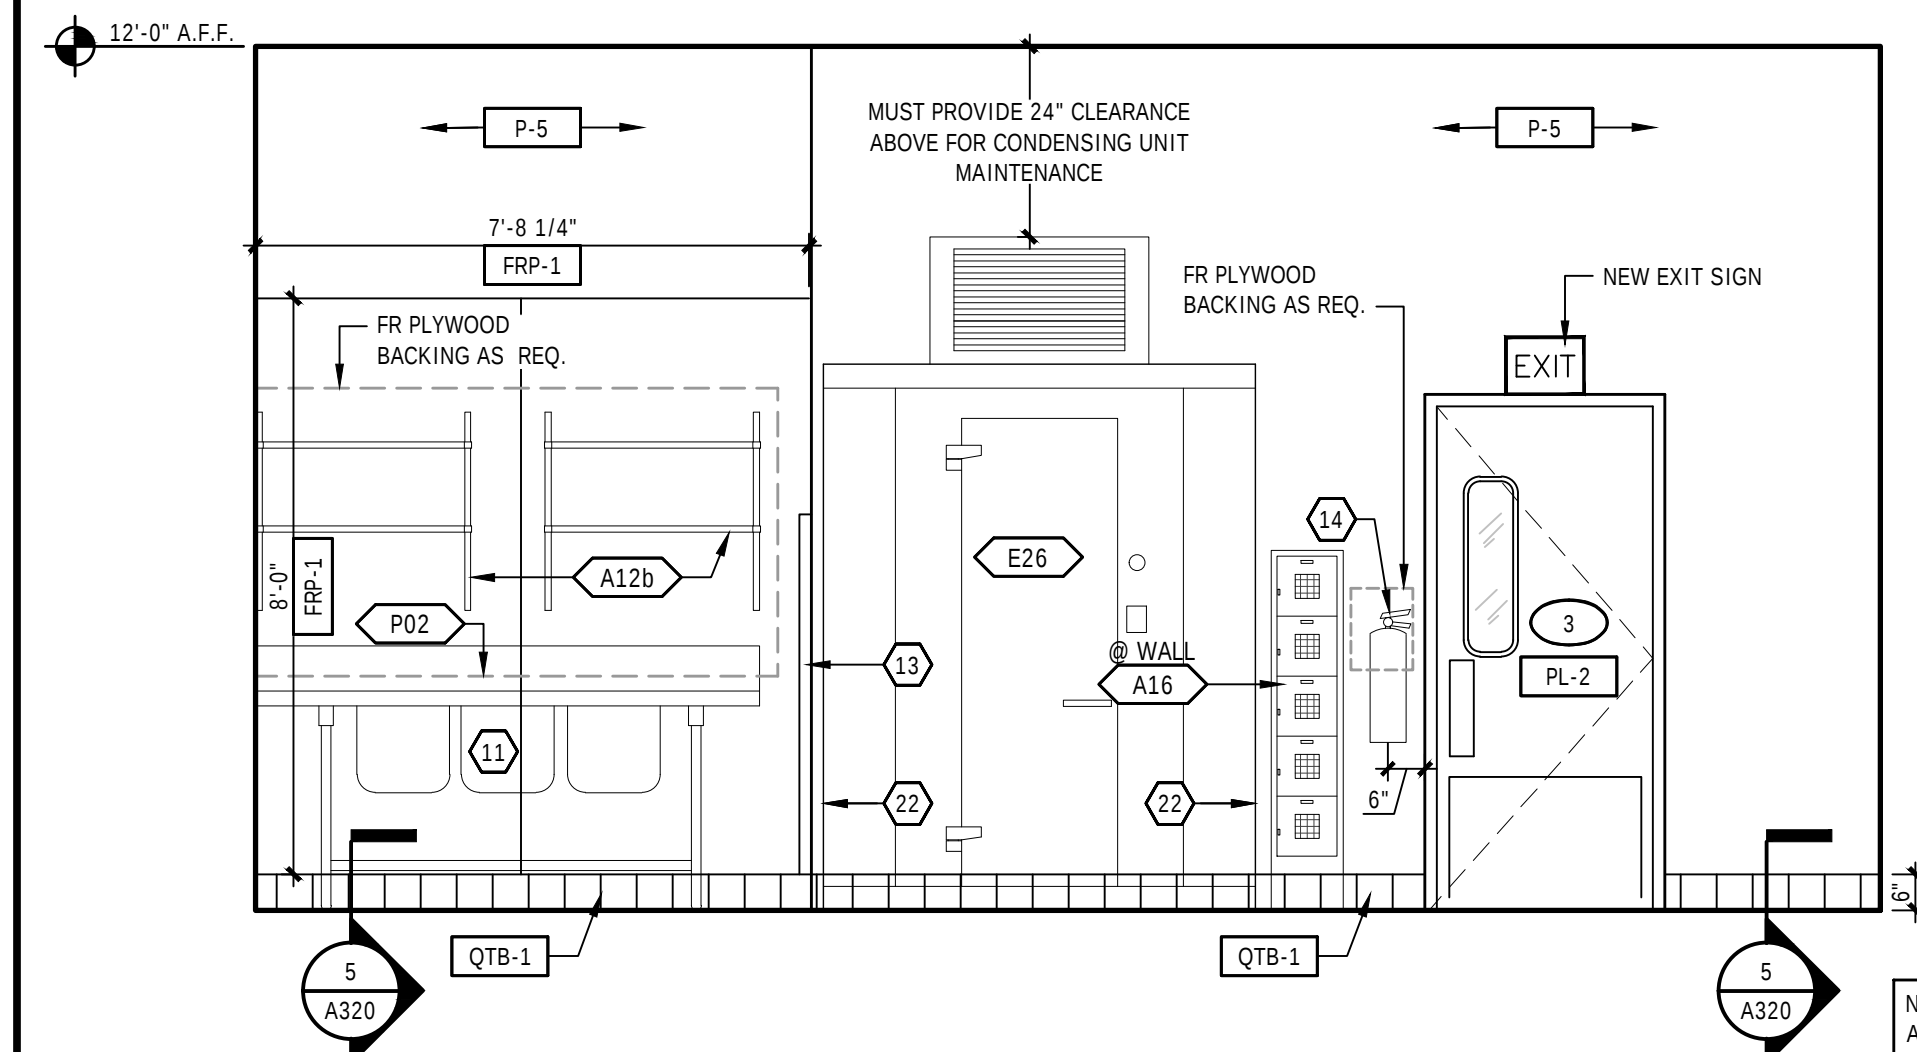

INTERIOR ELEVATION

3/8"=1'-0"	@SUPPORT ROOM
------------	---------------

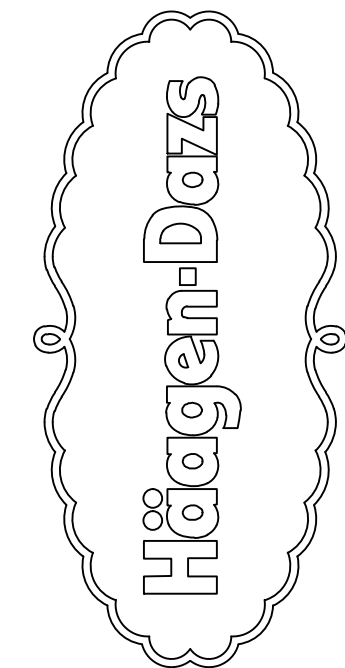

STORE #1436
40 S MAGNOLIA AVE.
OCALA, FL
34470

[illegible]

TIMOTHY M. LOTT
AIA, NCARB
2225 E Randol Mill Rd, Suite 300
Arlington, TX 76011
(817) 701-4807

SEAL




Project No.	250219
Scale	AS NOTED
Drawn	EL
Checked	CF
Date	10/09/25
Drawing Title	

INTERIOR
ELEVATIONS
(BOH & TOILET)

Drawing No.

A320

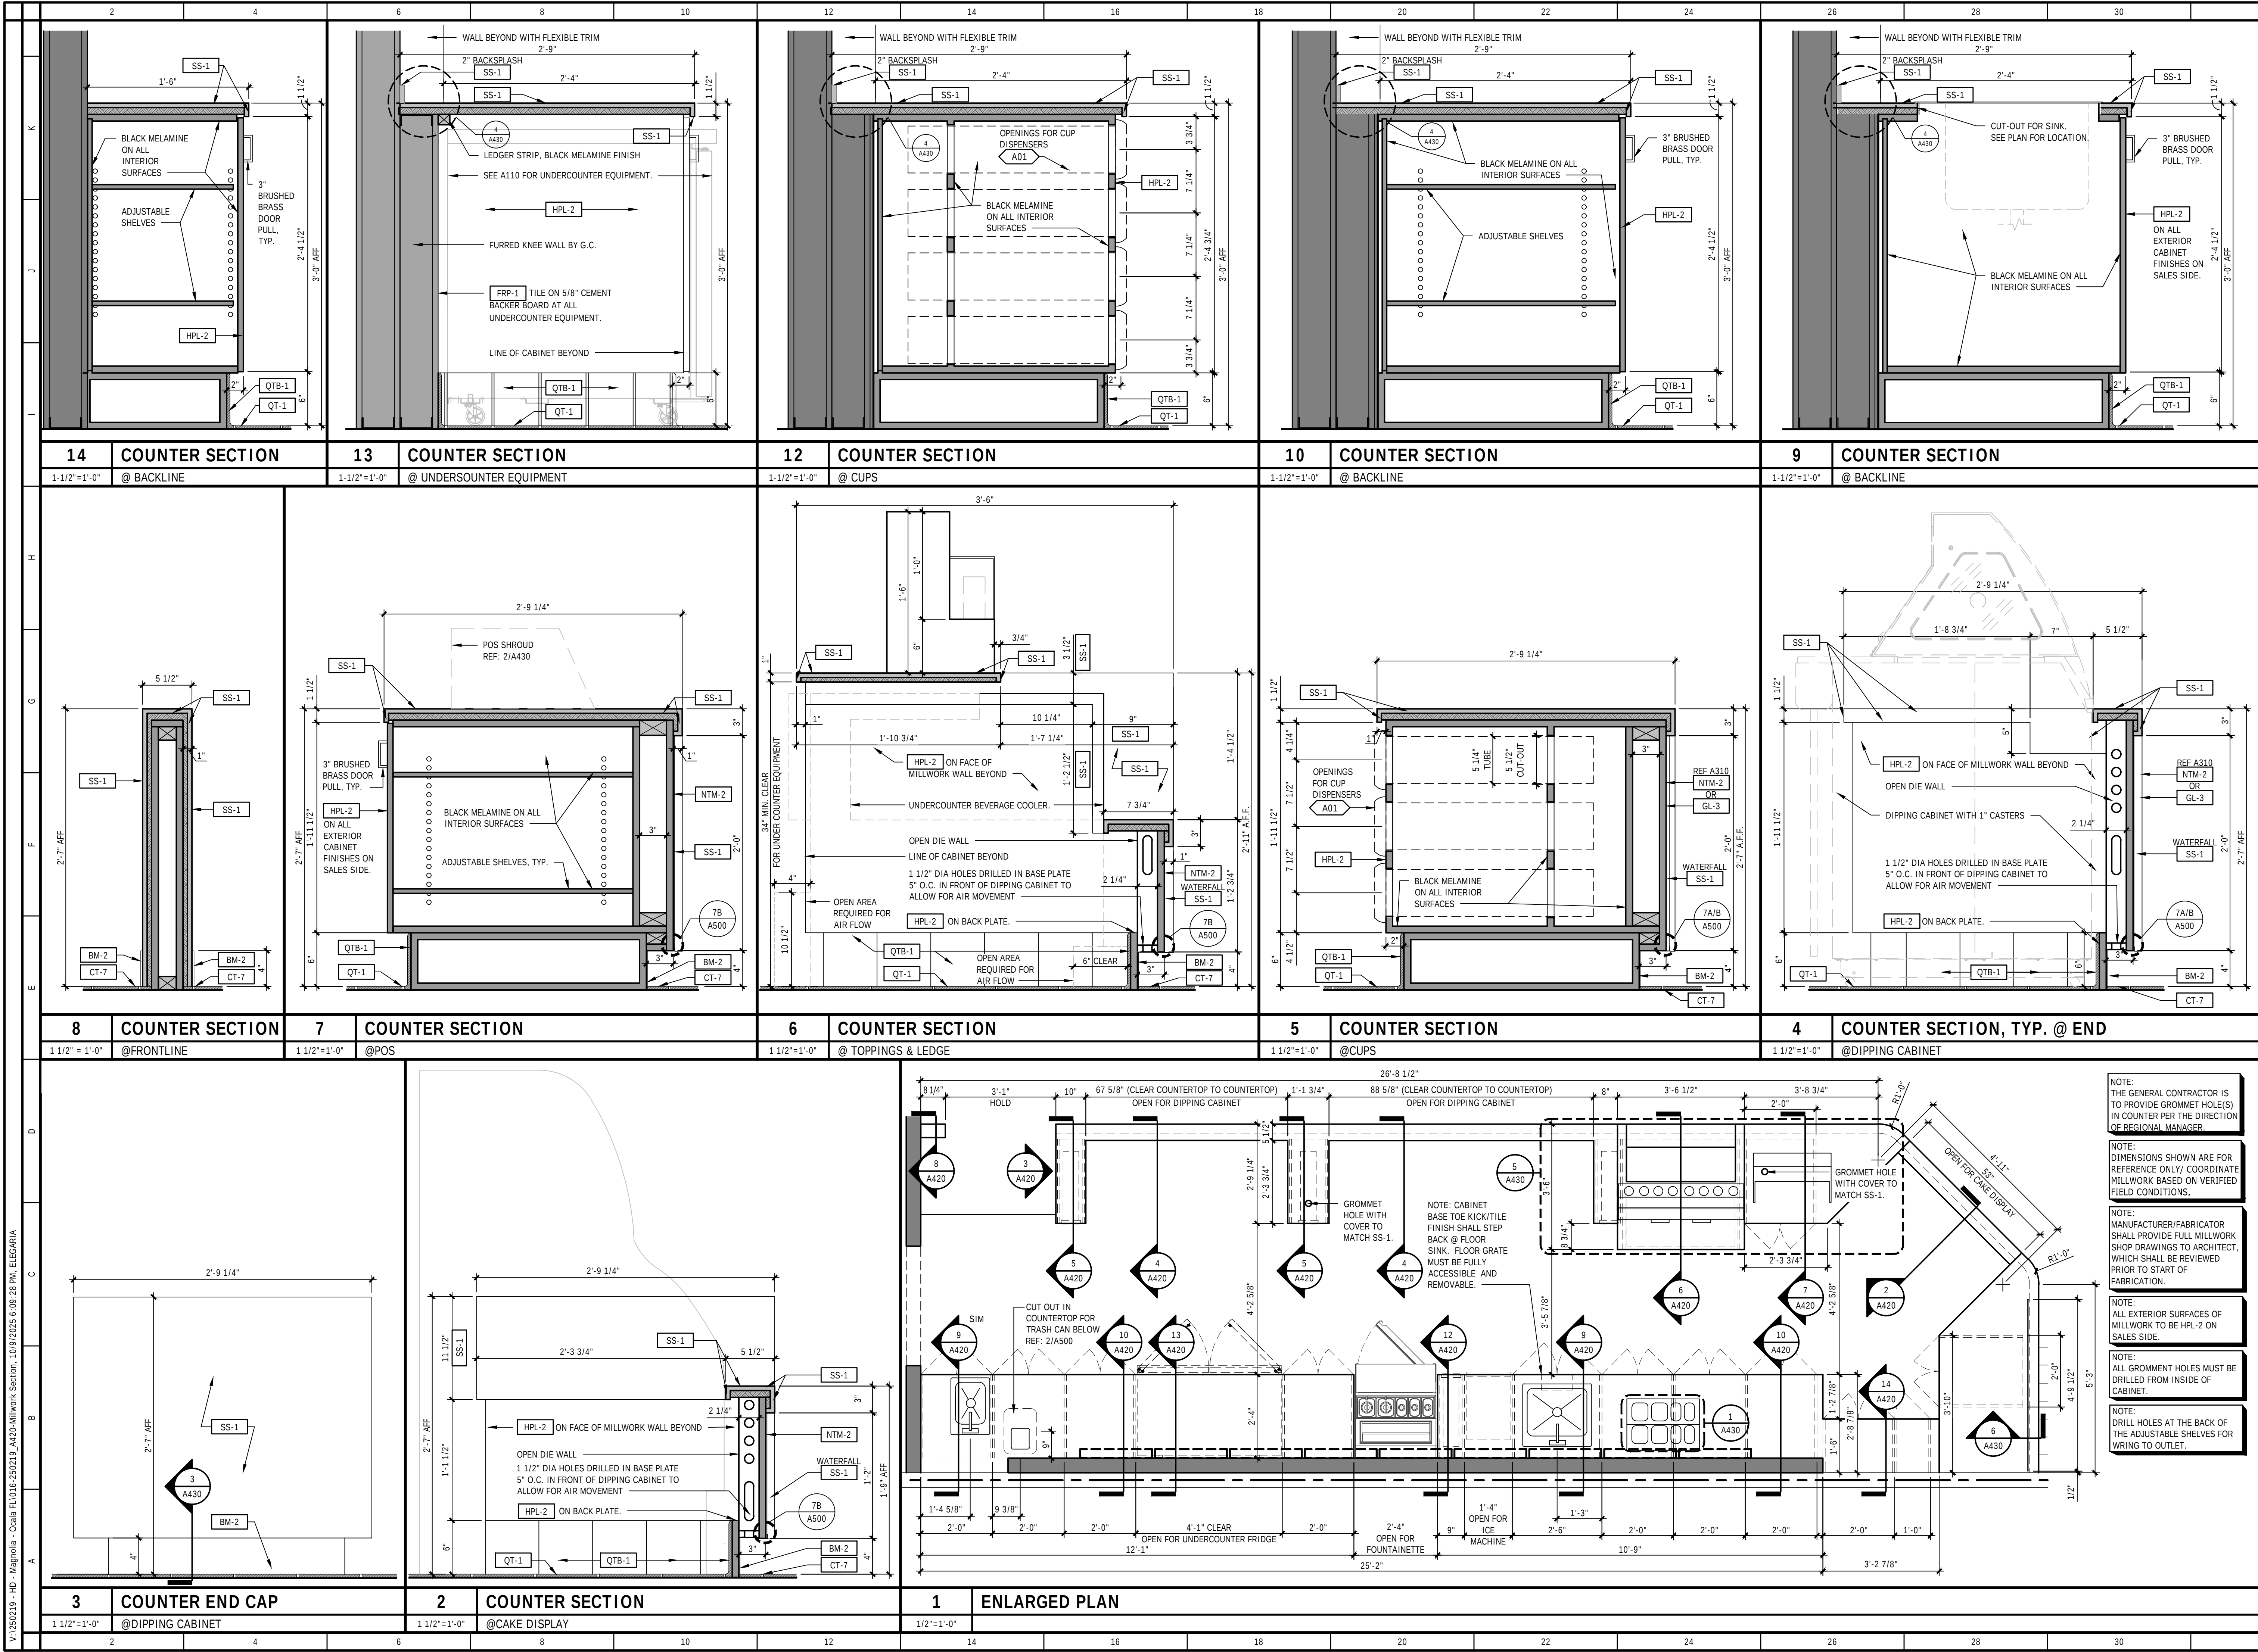

STORE #1436
40 S MAGNOLIA AVE.
OCALA, FL
34470

DESIGNER	
DATE	
REVISIONS	
NO.	

pdms
design group
Architecture + Engineering

2225 East Randol Mill Road, Suite #300
Arlington, Texas 76011
817.633.4200

This document contains information proprietary to PDMS Design Group and is intended to be used for the project and location only. It is not to be used for any other purposes and may not be reproduced or distributed to others without the prior written consent of PDMS Design Group.

TIMOTHY M. LOTT
AIA, NCARB
2225 E Randol Mill Rd, Suite 300
Arlington, TX 76011
(817) 701-4807

Project No. 250219
Scale AS NOTED
Drawn EL
Checked CF
Date 10/09/25
Drawing Title

ENLARGED
COUNTER PLAN
& DETAILS

Drawing No. **A420**

