



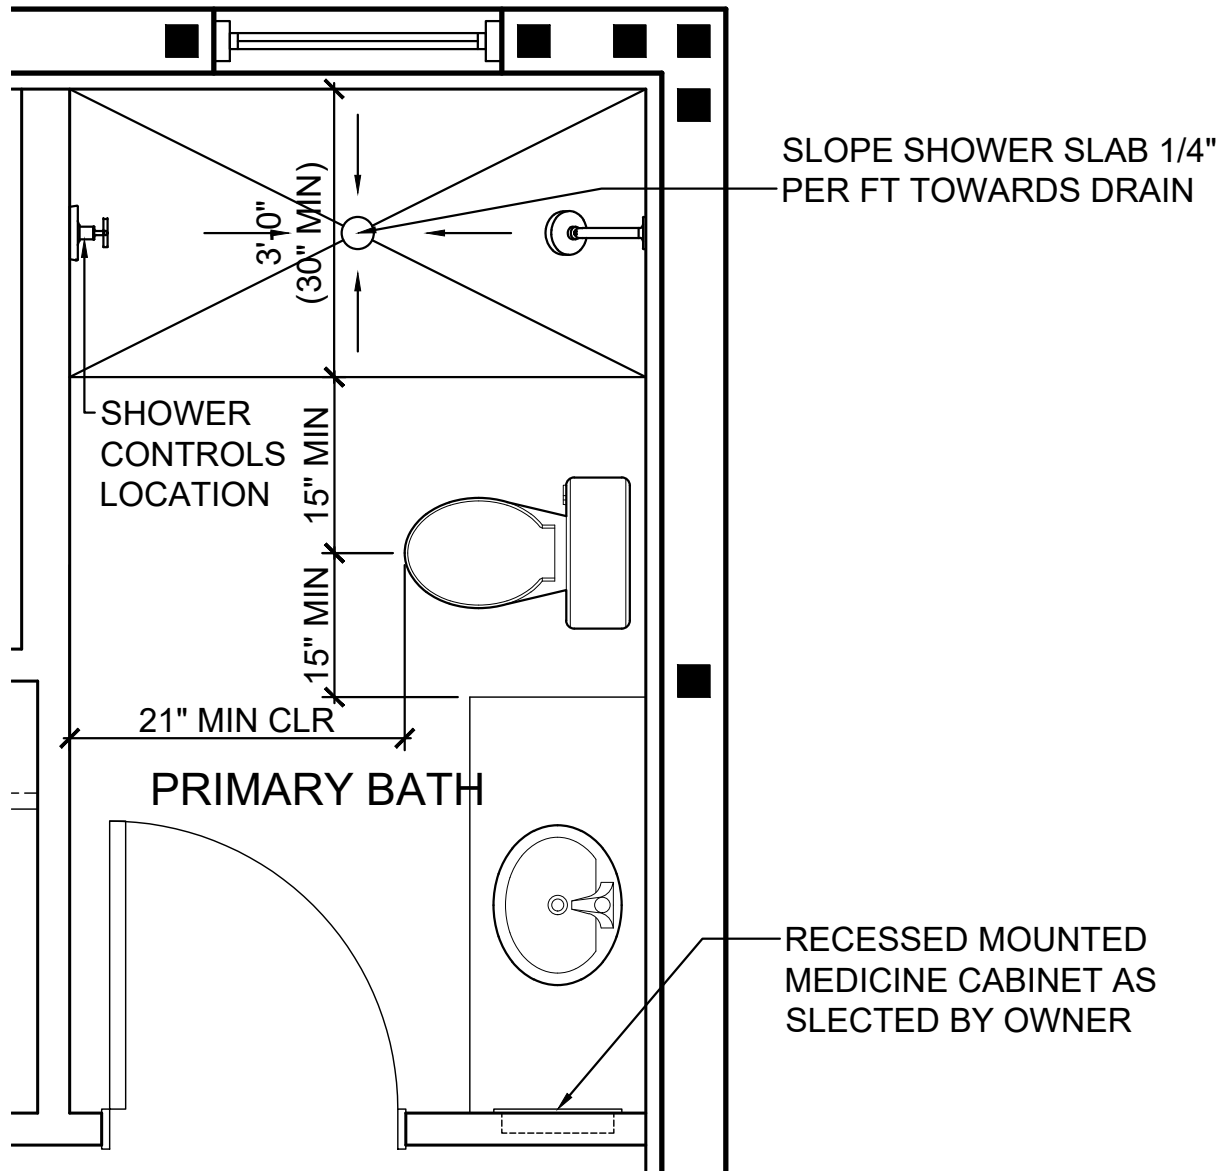


2 ENLARGED PRIMARY BATH PLAN
SCALE: 1/2" = 1'-0" (PRINTED @ 24X36)
SCALE: NTS = (PRINTED @ 11X17)

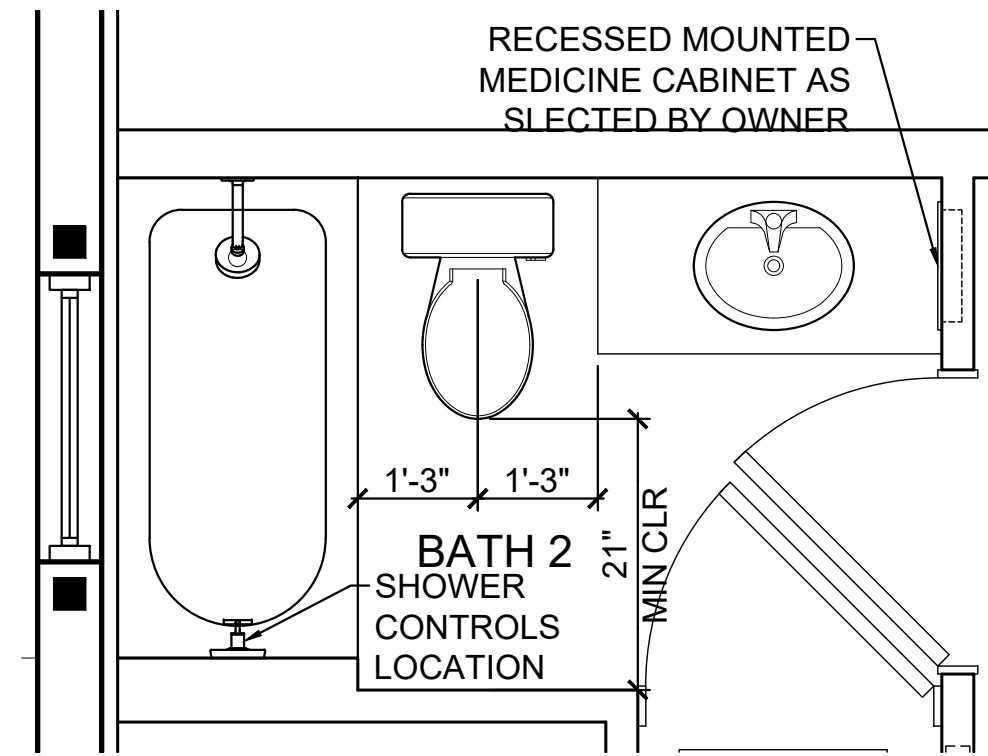

1 ENLARGED BATH PLAN
SCALE: 1/2" = 1'-0" (PRINTED @ 24X36)
SCALE: NTS = (PRINTED @ 11X17)

SQ. FT. DATA			WALL TYPE LEGEND		SYMBOL LEGEND	GENERAL NOTES
LIVING (A/C) AREA	1,175	SQ. FT.	 EXTERIOR WALL CONSISTING OF: PAINTED DECORATIVE CEMENTITIOUS STUCCO FINISH INSTALLED IN STRICT ACCORDANCE W/ ASTM C926. FLUID APPLIED AIR BARRIER OVER 8"X8"X16" CMU W/ #5 VERTICAL ROD IN FULLY GROUTED CELL W/ 3,000 PSI PEA GRAVEL GROUT @ 6'-0" O.C. MAX SPACING FINISH INTERIOR W/ 1/2" TEXTURED PRIMED & PAINTED GYP BD OVER 1X2 PT FURRING STRIPS @ 16" O.C. OVER FOIL FACED THERMAX R-5.0 MIN. FOIL TAPE ALL JOINTS AND FILL ALL VOIDS	 WINDOW SYMBOL	1. ALL WORK SHALL BE EXECUTED IN ACCORDANCE WITH ALL GOVERNING NATIONAL, STATE AND LOCAL CODES AND REGULATIONS. 2. FOR SPECIFIC SITE PLAN INFORMATION REFER TO CIVIL DRAWINGS PREPARED BY OTHERS. 3. ALL BUILDING ELEMENTS SHALL BE INSTALLED VERTICALLY W/ NO HORIZONTAL JOINTS. 4. DUE TO MATERIAL TOLERANCES THE GENERAL CONTRACTOR MUST VERIFY ALL DIMENSIONS WITH ACTUAL CONDITIONS ON THE SITE AND REPORT ANY DIFFERENCES TO THE ARCHITECT FOR INTERPRETATION AND RESOLUTION PRIOR TO COMMENCEMENT OF WORK. 5. ALL TRIM MATERIALS SHALL BE PAINT GRADE QUALITY UNLESS NOTED OTHERWISE. VERIFY FINISH WITH OWNER PRIOR TO ANY MATERIAL PURCHASES. 6. ALL WINDOWS, DOORS, NICHES, AND OPENINGS SHALL BE CASED WITH MIN. 4" NOMINAL SOLID PAINT GRADE TRIM WITH VERIFY PROFILE & CASING METHOD (MITERED, BUTT JOINTED, ECT.) AND CASING DESIGN AND FINISH WITH OWNER PRIOR TO ANY MATERIAL PURCHASE. 7. PROVIDE CONT. BLOCKING CONSISTING OF P.T. 1X8 MIN. AT CMU WALL (FURRED AREA) OR 2X8 MIN. BLOCKING AT FRAME WALL. TYP. IN RESTROOMS, KITCHENS, LOUNGES, ECT. TO RECEIVE PLUMBING FIXTURES, GRAB BARS ACCESSORIES, CABINETS, WINDOW AND DOOR CASINGS, CROWN MOLDING, ECT. 8. PROVIDE 1/2" THICK HARDIRBACKER BOARD (BY JAMES HARDIE BUILDING PRODUCTS AT ALL INTERIOR RESTROOM WALLS, CEILINGS, KITCHEN WET WALLS (PLUMBING FIXTURES) OR ANY OTHER WET LOCATION.	
EXTERIOR COVERED AREAS (NON A/C)	32	SQ. FT.		 LINTEL SYMBOL		
GRAND TOTAL	1,207	SQ. FT.		 DOOR SYMBOL		
			 INTERIOR NON-LOAD BEARING PARTITION WALL CONSISTING OF: 1/2" TEXTURED PRIMED & PAINTED GYP BD. ON EA. SIDE OF 2x4 WOOD STUDS AT 16" O.C. W/ (1) 2x4 TOP PLATES AND (1) P.T. 2x4 BASE PLATE SECURED TO CONC. SLAB	NOTE: REFER TO DOOR, WINDOW, AND LINTEL SCHEDULES FOR ADDITIONAL INFORMATION.		

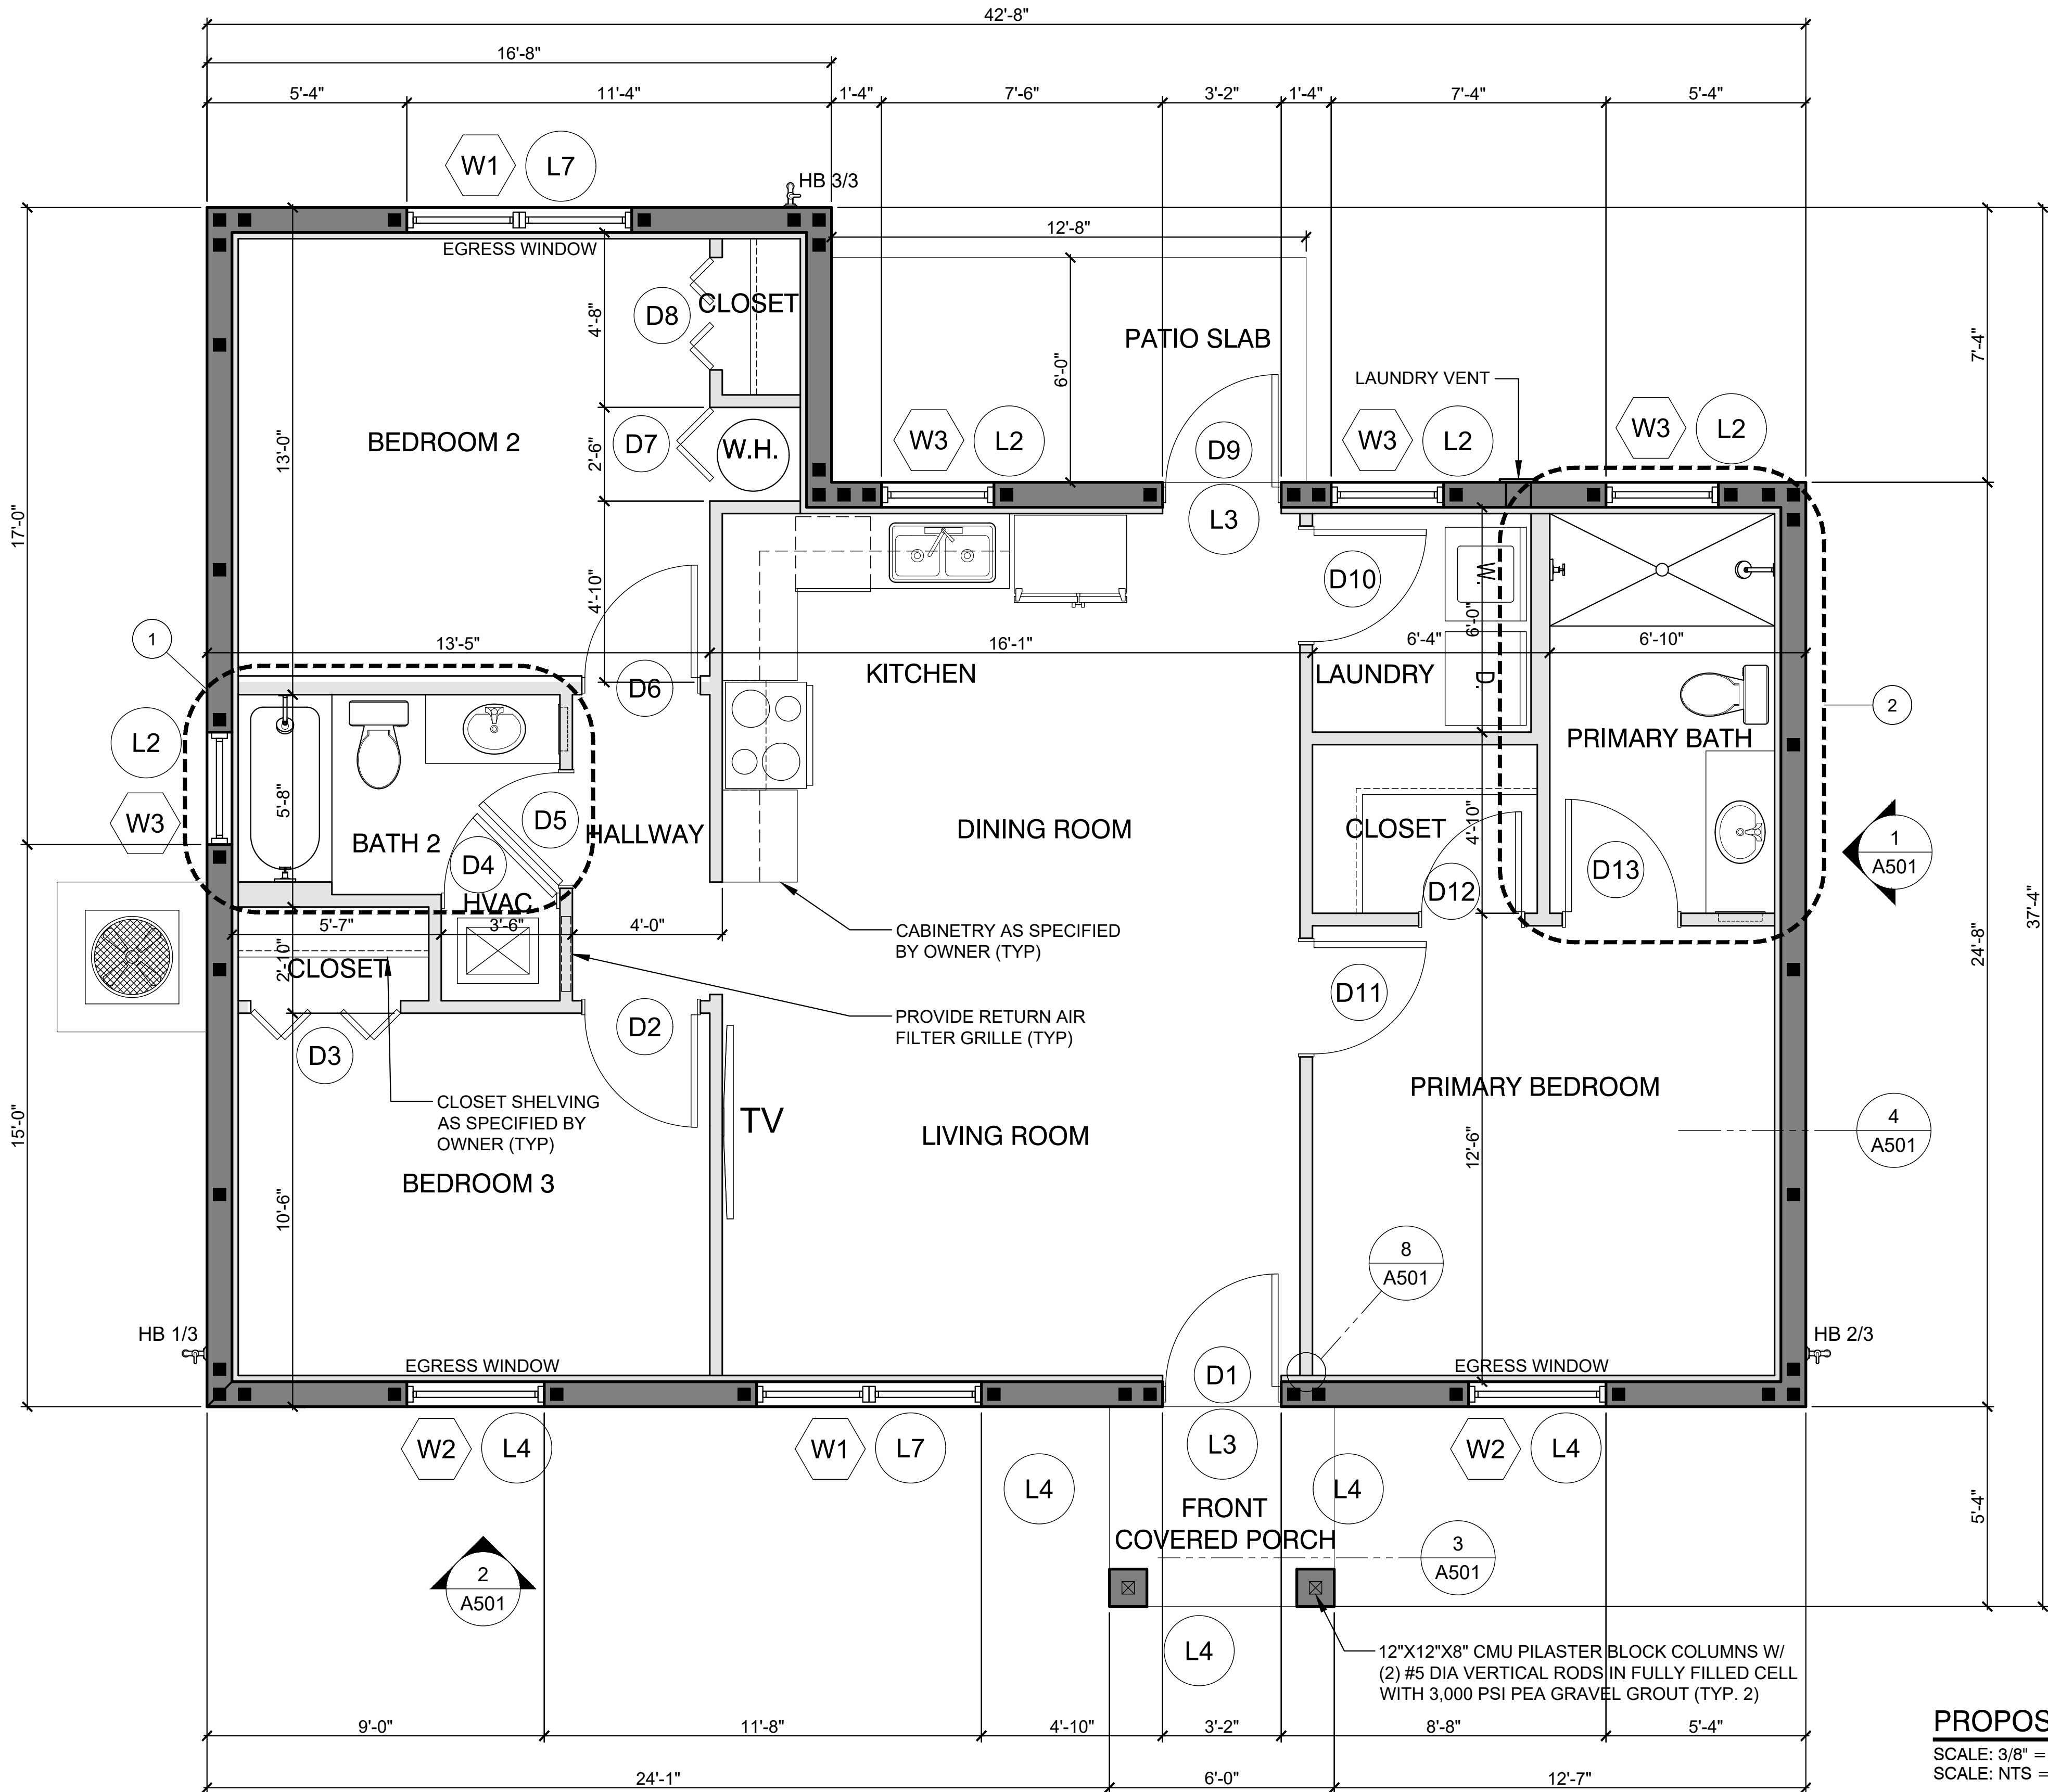

PROPOSED FLOOR PLAN
SCALE: 3/8" = 1'-0" (PRINTED @ 24X36)
SCALE: NTS = (PRINTED @ 11X17)

COPYRIGHT © 2024 ALL RIGHTS RESERVED. THESE PLANS AND DRAWINGS ARE THE PROPERTY OF RISPOLI & ASSOCIATES, INC. ANY UNAUTHORIZED USE MAY RESULT IN LEGAL ACTION.	REVISIONS	

DIGITAL SIGNATURE
JOSEPH A. RISPOLI, AIA
ARCHITECT, FL. LICENSE: AR95439

RISPOLI & ASSOCIATES
ARCHITECTURE, INC.
114 SOUTH MAGNOLIA AVENUE, OCALA, FLORIDA 34471
(352) 620-0909 WWW.RISPOLIARCHITECT.COM
JOE@RISPOLIARCHITECT.COM

A NEW RESIDENCE FOR:
CITY OF OCALA - CYNTHIA RAINES THOMAS
PARCEL 22126-001-00
OCALA, FLORIDA
CONSTRUCTION DOCUMENTS

DRAWN RAA	PROJECT NO. 2437
CHECKED RAA	DATE 04.07.25

A201
SHEET NO.