


FLOOR PLAN
SCALE: 1/4"=1'-0"

TAG LEGENDS	WALL TYPE SCHEDULE
D# DOOR TYPE TAGS(SCHEDULE SEE A4)	NEW FIRE WALL
W# WALL TYPE TAGS(DETAIL SEE A4)	NEW WALL
# EQUIPMENT SCHEDULE	EXISTING WALL

FINISH SCHEDULE				
	TOE BASE COVING	FLOOR	CEILING	WALL
DINING AREA	CERAMIC TILE.	CERAMIC TILE.	EXISTING OPEN CEILING	GYPSUM FIRECODE PAINTED W/2-COATS OF EPOXY PAINT.
SUSHI AREA	CERAMIC TILE.	CERAMIC TILE.	DRY WALL CEILING, NON-PERFORATED,NON-FISSURED, SMOOTH, WASHABLE, LIGHT-IN COLOR. VINYL FINISH.	GYPSUM FIRECODE PAINTED W/2-COATS OF EPOXY PAINT.
TOILET ROOM	CERAMIC TILE.	CERAMIC TILE.	EXISTING DRY WALL CEILING, NON-PERFORATED,NON-FISSURED, SMOOTH, WASHABLE, LIGHT-IN COLOR. VINYL FINISH.	CERAMIC TILE FINISHED 4 FEET A.F.F. ,GYPSUM FIRECODE PAINTED W/2-COATS OF EPOXY PAINT.
KITCHEN AND SALES AREA	QUARRY TILE.	QUARRY TILE.	2X4 LAY-IN ACOUSTICAL CEILING, NON-PERFORATED,NON-FISSURED, SMOOTH, WASHABLE, LIGHT-IN COLOR. VINYL FINISH.	STAINLESS STEEL BEHIND HOOD AREA AND FRP PANELING IN OTHER AREA.


- FINISH NOTES:
- ALL FINISHED SURFACES SHALL BE SMOOTH, EASILY CLEANABLE AND NON ABSORBENT.
 - ALL DAMAGE CREATED OR DISCOVERED IN THE PROCESS OF THE CONSTRUCTION PHASE OF THE PROJECT SHALL BE PROPERLY REFINISHED IN AN APPROVABLE MANNER.
 - ALL SURFACE PENETRATIONS, CRACKS AND CREVICES ARE TO BE SEALED TO ELIMINATE VERMIN HARBORAGE AREAS.
 - ALL PLUMBING PIPES, ELECTRICAL CONDUITS, GAS LINES, ETC. SHALL BE KEPT WITHIN THE WALL CAVITIES, ABOVE THE CEILING OR UNDER THE FLOOR. IF THE GAS LINE MUST BE RUN OUTSIDE OF THE WALLS, THEN A CLEANA/LBE BRACKET MUST BE USED THAT WILL BRACE THE PIPE AT LEAST 1" OF THE WALL AND AT LEAST AT 12" OFF THE FLOOR.
 - UTILITY LINES SHOULD BE STUBBED OUT OF THE WALLS, FLOORS OR CEILINGS AT EACH PIECE OF EQUIPMENT SERVED.

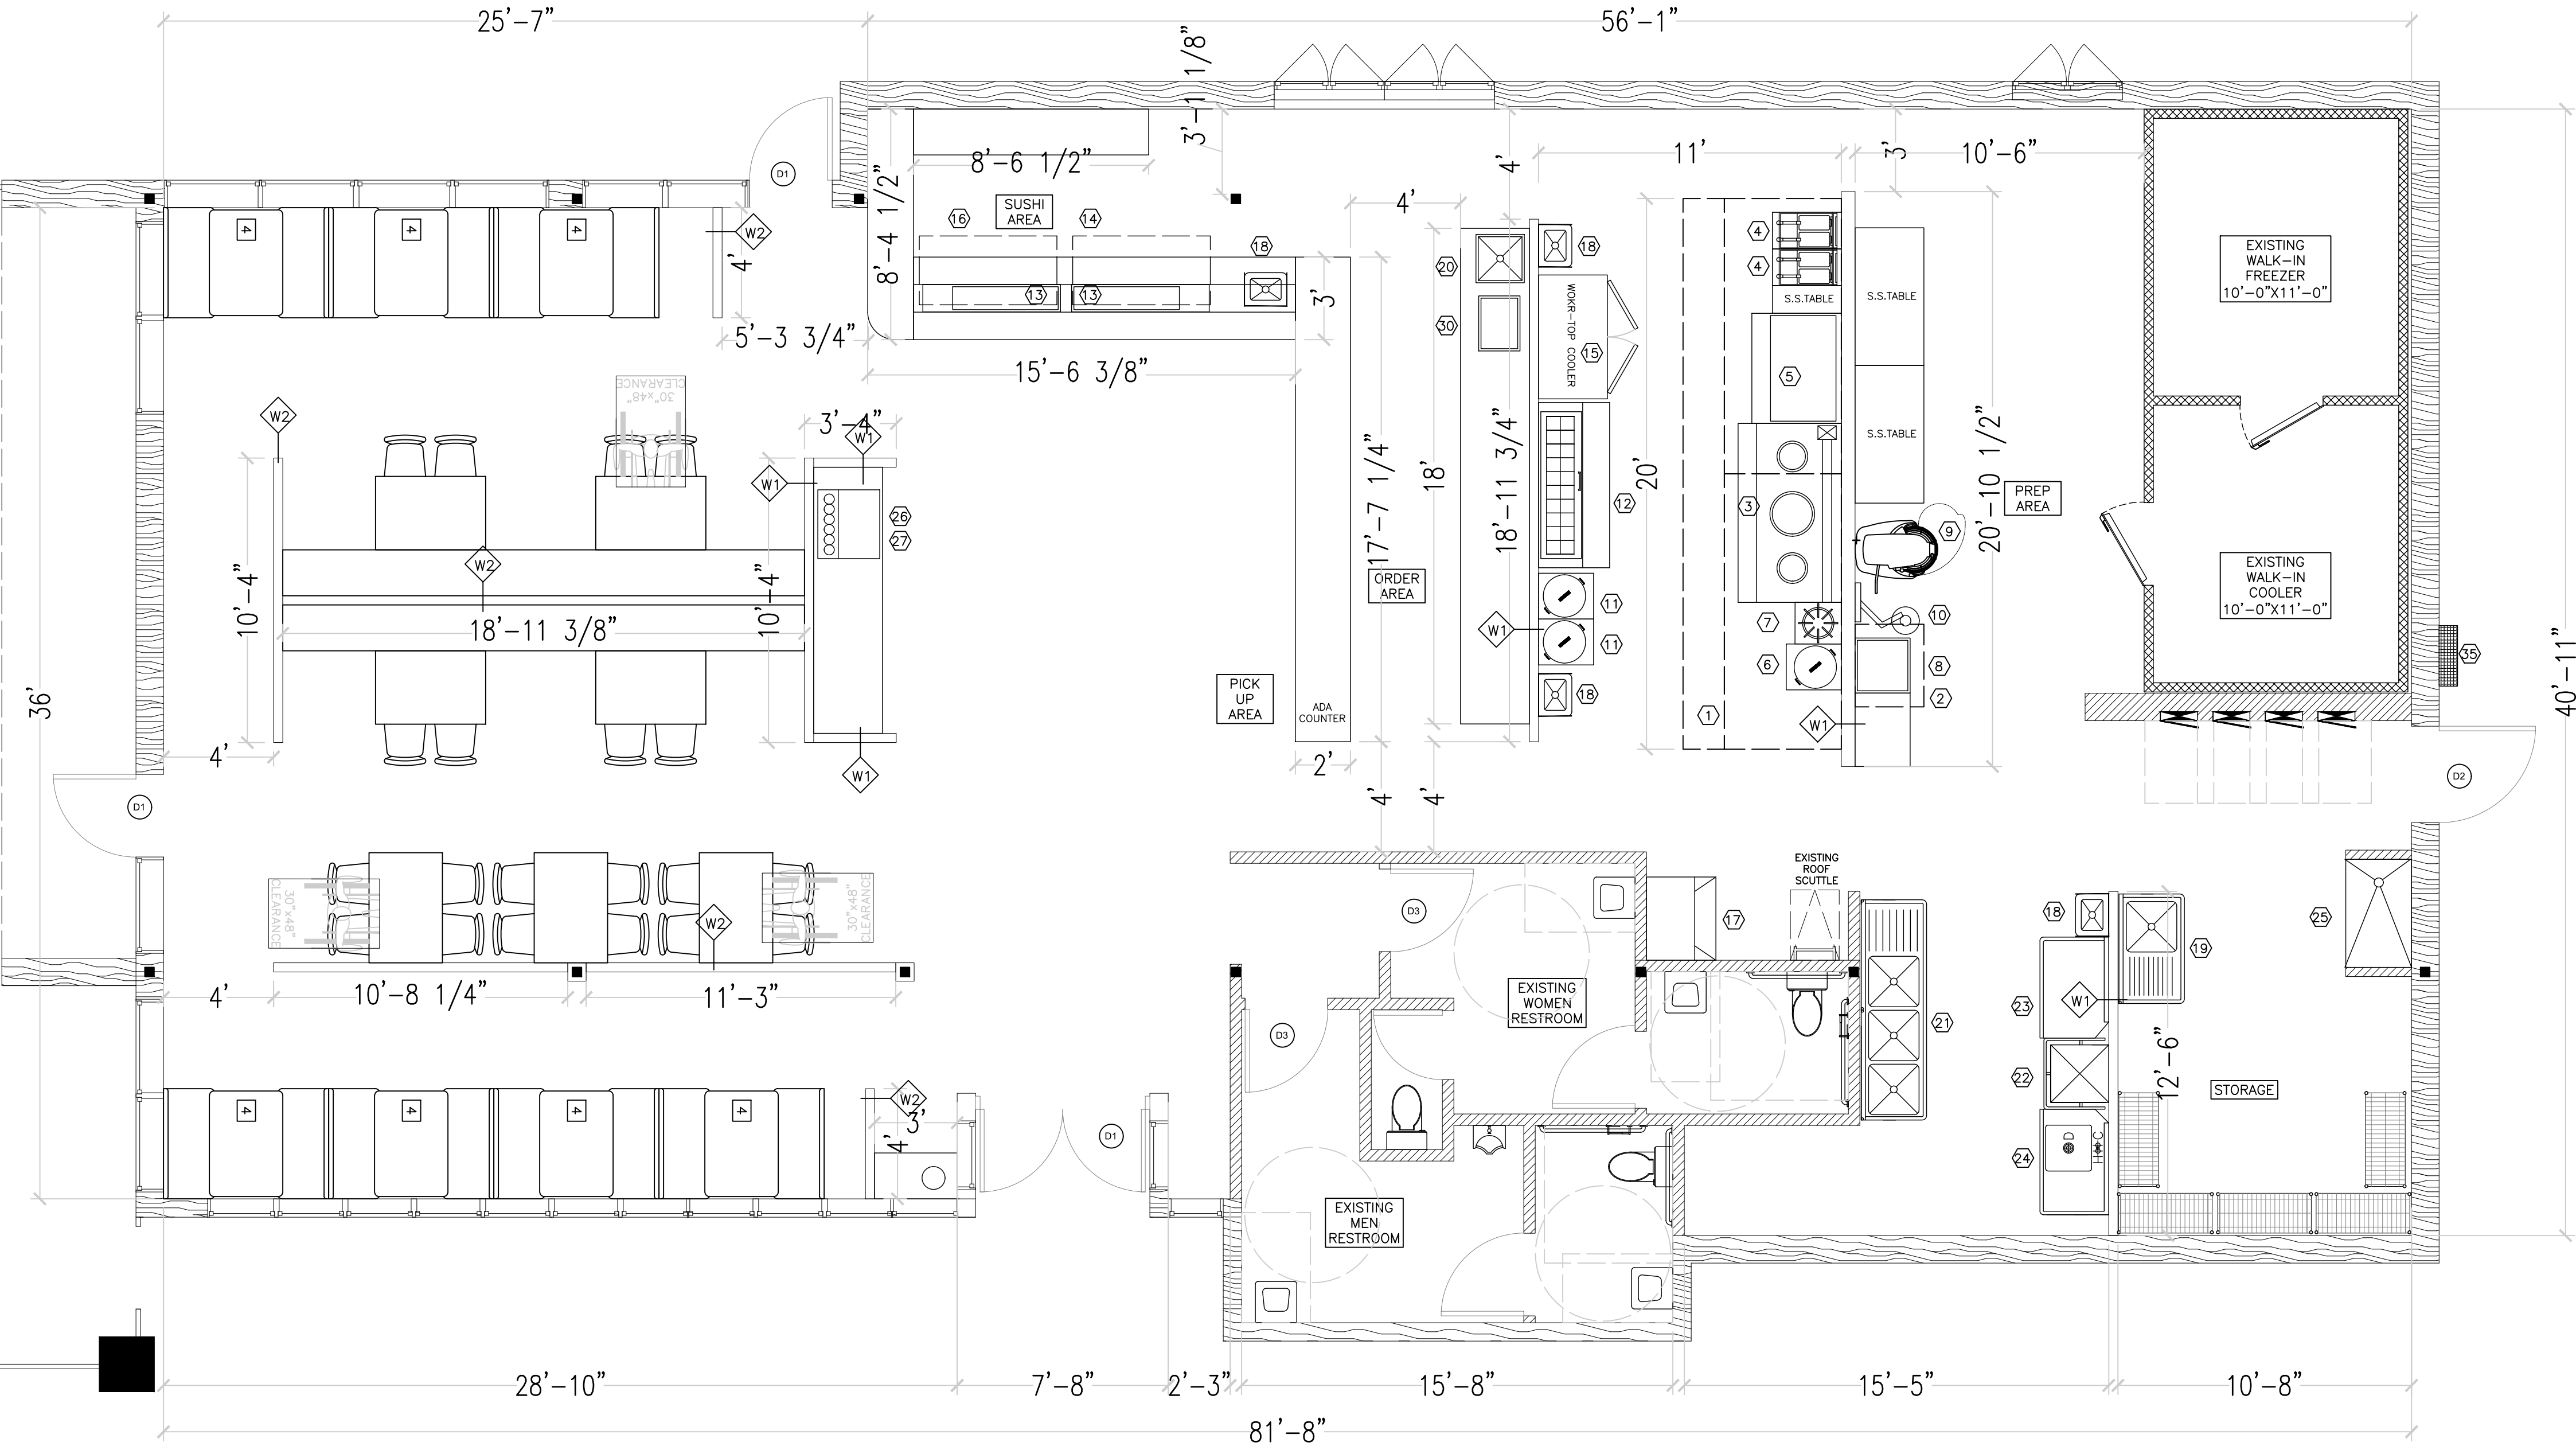

EQUIPMENT SCHEDULE															
NO.	QTY.	DESCRIPTION	MANUFACTURE	MODEL	U.L.N.	ELECTRICAL			GAS		WATER		WASTE		
					S.F.	VOLT	PHS.	HP.	KW.	SIZE	BTUH	C.W.	H.W.	DIR.	INO.
1	2	HOOD	ECON AIRE		U.L.										
2	1	HOOD	ECON AIRE		U.L.										
3	1	CHINESE WOK	WIN SUPPLY	WR-300	N.S.F.					3/4"	300,000 BTU	3/4"			3"
4	2	DEEP FRYER	PTICO	SG-14	N.S.F.					3/4"	110,000 BTU				
5	1	GRIDDLE	COOKING PERFORMANCE	GM-CPG-48-NL	N.S.F.					3/4"	120,000 BTU				
6	1	RICE COOKER	RINNAI	RER55AS	N.S.F.					1/2"	35,000 BTU				
7	1	SOUP STOVE	COOKING PERFORMANCE	CPG-SP-18-N	N.S.F.					3/4"	80,000 BTU				
8	1	DONUT FRYER	BELSHAW	724CG-120V-NG	N.S.F.	120	1	1/3		3/4"	60,000 BTU				
9	1	MIXER	ADMIRAL CRAFT	BDPM-60	N.S.F.	208	3		2.08						
10	1	DOUGH DEPOSITOR	BELSHAW ADMATIC	TYPE F	N.S.F.	115	1		0.57						
11	2	RICE WARMER	AVANTCO	RCSA60	N.S.F.	120	1	1/3	1.55						
12	1	SANDWICH UNIT	AVANTCO	APT-72M-HC	N.S.F.	115	1	1/3	0.59						
13	2	SUSHI CASE	HOSHIZAKI	HNC-120BA-R-SUH	N.S.F.	115	1		0.36						
14	1	UNDER FREEZER	AVANTCO	SS-UC-48F-HC	N.S.F.	115	1	1/3	0.58						
15	1	UNDER COOLER	AVANTCO	SS-UC-72R-HC	N.S.F.	115	1	1/3	0.58						
16	1	UNDER COOLER	AVANTCO	SS-UC-48R-HC	N.S.F.	115	1	1/3	0.58						
17	1	ICE MAKER	MANITOWOC	S850 & B570	N.S.F.	120	1		2.35			1/2"			3"
18	4	HAND SINK	REGENCY	600HS12SP	N.S.F.							1/2"	1/2"	2"	
19	1	PREP SINK	REGENCY	600S124241G	N.S.F.							1/2"	1/2"		3"
20	1	DROP-IN PREP SINK	REGENCY	600DI12012	N.S.F.							1/2"	1/2"		3"
21	1	3-COMP. SINK	REGENCY	600S324242G	N.S.F.							3/4"	3/4"		3"
22	1	DISHWASHER	JACKSON	CONSERVER XL	N.S.F.	115	1		1.52			1/2"	1/2"		3"
23	1	CLEAN TABLE	EAGLE	CDTL-48-16/4	N.S.F.										
24	1	SOILED TABLE	EAGLE	SDTR-48-16/4	N.S.F.										
25	1	MOP SINK	EXISTING		N.S.F.							1/2"	1/2"	2"	
26	1	ICE MAKER	MANITOWOC	KM-1340MWJ	N.S.F.	208	1		2.35			1/2"			3"
27	1	SODA DISP.	PROVIDE BY COCA-COLA		N.S.F.							1/2"			
28	1	WALK-IN FREEZER	EXISTING	10'-0" X 11'-0"	N.S.F.	208	1	1/3	1.52						
29	1	WALK-IN COOLER	EXISTING	10'-0" X 11'-0"	N.S.F.	208	1	1/3	1.52						
30	1	ICE BIN	REGENCY		N.S.F.										
31	1	COUNTER		CUSTOM											
32	1	WALL MOUNTED SHELVES(Stainless Steel)	EAGLE	PWE-14-3S	N.S.F.										
33	LOT	TABLE(Stainless Steel)	EAGLE	T3036, T3072	N.S.F.										
34	LOT	SHELVES(Stainless Steel)	EAGLE	1842S	N.S.F.										
35	1	WATER HEATER	RINNAI	CU199	N.S.F.					3/4"	199,000 BTU	3/4"	3/4"		

DESIGN:
GREENLOGIC, LLC
P.O.BOX 678 GOTHIA
FLORIDA 34734 (407)
808-1816 CA# 30527 A&E

THIS ITEM HAS BEEN ELECTRONICALLY
SIGNED AND SEALED BY [ALLEN G LIANG]
USING A DIGITAL SIGNATURE AND DATE.
PRINTED COPIES OF THIS DOCUMENT ARE
NOT CONSIDERED SIGNED AND SEALED
AND ALL SIGNATURES MUST BE VERIFIED
ON ANY ELECTRONIC COPIES.

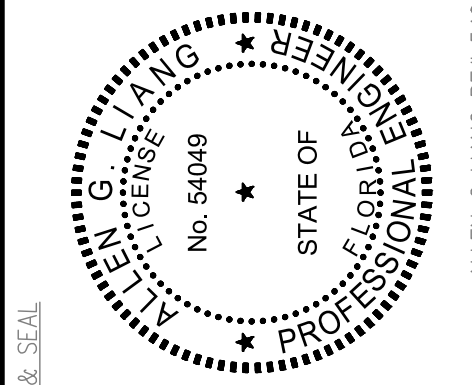

PROJECT:
KOTO HIBACHI EXPRESS
3811 S.W. COLLEGE ROAD
OCALA, FL 34474

SHEET TITLE
FLOOR PLAN

REVISION

1	
2	
3	
4	
5	
6	
7	

PROJECT TYPE: RENOVATION
SCALE: AS SHOWN
ISSUED DATE: 08-07-2024
DRAWN BY: A.FENG
CHECKED BY: A.LIANG
SHEET